
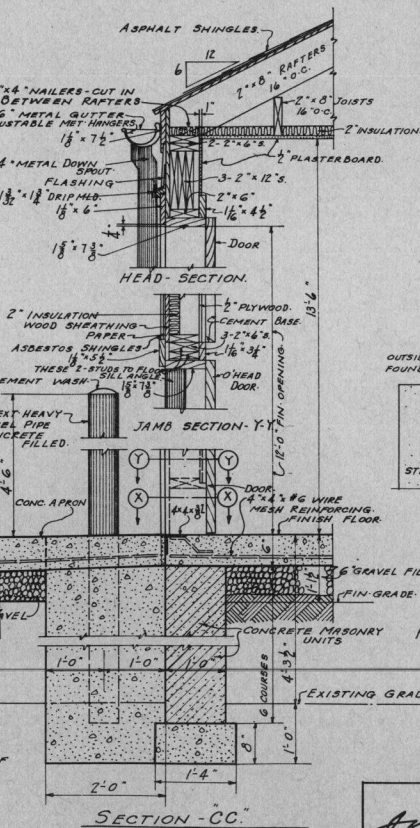
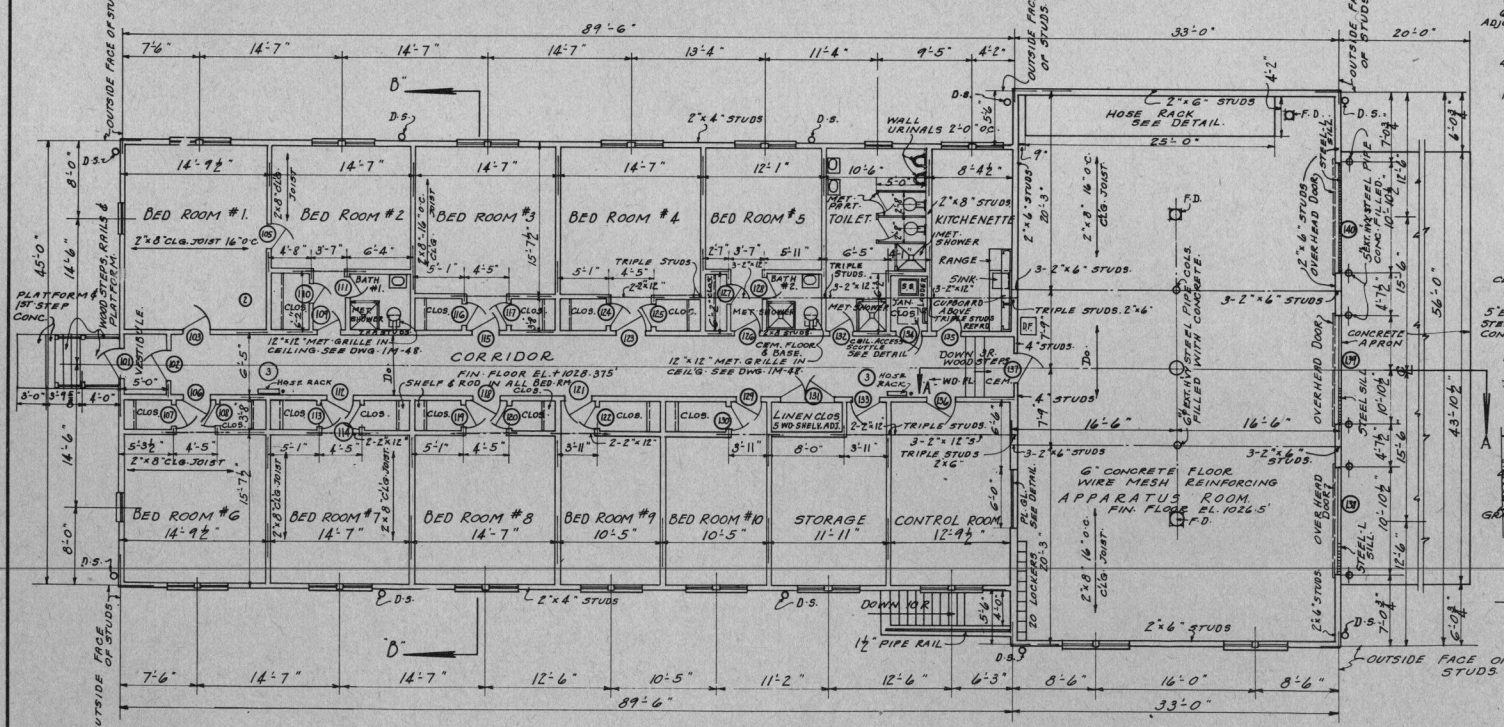
 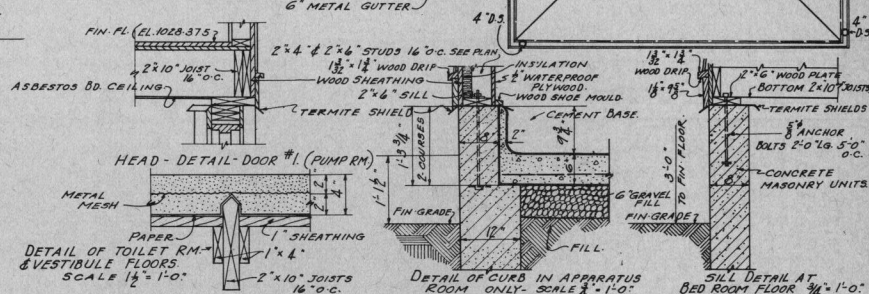


ROOM FINISH SCHEDULE

ROOM TITLE	FLOOR	BASE	WAINSCOT	WALLS	CEILING	TRIM	REMARKS	ROOM TITLE	FLOOR	BASE	WAINSCOT	WALLS	CEILING	TRIM	REMARKS
LIVING RM #1	WOOD	WOOD	NONE	2" PL. BD.	2" PL. BD.	WOOD		TOILET	CEM.	CEM.	NONE	2" PL. BD.	2" PL. BD.	WOOD	
BED ROOM #2	Do	Do	Do	Do	Do	Do		JANITORS CLOS.	CEM.	CEM.	Do	Do	Do	Do	
BED ROOM #3	Do	Do	Do	Do	Do	Do		KITCHENETTE	WOOD	WOOD	Do	Do	Do	Do	
BED ROOM #4	Do	Do	Do	Do	Do	Do		LINEN CLOS.	Do	Do	Do	Do	Do	Do	SEE DWG. 106-B FOR SHELVING.
BED ROOM #5	Do	Do	Do	Do	Do	Do		STORAGE	Do	Do	Do	Do	Do	Do	
BED ROOM #6	Do	Do	Do	Do	Do	Do		CONTROL RM.	Do	Do	Do	Do	Do	Do	
BED ROOM #7	Do	Do	Do	Do	Do	Do		CLOSETS	Do	Do	Do	Do	Do	Do	SEE DWG. 106-B FOR SHELVING.
BED ROOM #8	Do	Do	Do	Do	Do	Do		VESTIBULE	CEM.	CEM.	Do	Do	Do	Do	
BED ROOM #9	Do	Do	Do	Do	Do	Do		CORRIDOR	WOOD	WOOD	Do	Do	Do	Do	
BED ROOM #10	Do	Do	Do	Do	Do	Do		APPARATUS ROOM	CEM.	CEM.	PLYWOOD	Do	Do	Do	
BATH #1 & #2	CEM.	CEM.	Do	Do	Do	Do		PUMP ROOM	Do	NONE	NONE	ROUGH	ASBESTOS BOARD	Do	



DOOR SCHEDULE - SEE DWG. 106-B

DOOR NUMBER	TYPE	MASONRY OPENING	WALL THICKNESS	WIDE	HIGH	THICK	MATERIAL	FRAME & TRIM	THRESH.	GLAZING	LINTEL	REMARKS
101	A-2	4" STUD	3'-0"	7'-0"	1 1/2"	WOOD	WOOD	METAL	CLEAR	WOOD		
102	B-3	Do	Do	Do	Do	Do	Do	Do	Do	Do	Do	
103	B-3	Do	Do	Do	Do	Do	Do	Do	Do	Do	Do	
104-110	B-3	Do	Do	Do	Do	Do	Do	Do	Do	Do	Do	
110-111	C-7	Do	Do	Do	Do	Do	Do	Do	Do	Do	Do	CUT 1/2\"/>
111	C-3	Do	Do	Do	Do	Do	Do	Do	Do	Do	Do	PAIR WITH REBATE SEE DETAIL.
112-114	C-4	Do	Do	Do	Do	Do	Do	Do	Do	Do	Do	CUT 1/2\"/>
115-116	C-1	Do	Do	Do	Do	Do	Do	Do	Do	Do	Do	
118-119, 140	OH-4	6\"/>										
1	A-5	3\"/>										
104 OMITTED												

INDEX OF DRAWINGS

DWG. NO.	TITLE	APPLIES TO BLDG.
1A-48	FOUNDATION - FLOOR & ROOF PLANS - DETAILS	BUILDING 1048
2A-48	ELEVATIONS & SECTIONS	Do Do
1M-48	MECHANICAL HEATING & PLUMBING PLAN	Do Do
1E-48	ELECTRICAL POWER & LIGHTING LAYOUT	Do Do
102-D	STANDARD DETAILS OF CONSTRUCTION	
102-B	ENTRANCE & EXTERIOR DETAILS	ADMINISTRATION AREA
104-B	SCHEDULE OF DETAILS	Do Do
106-B	INTERIOR DETAILS	Do Do
107-B	MISCELLANEOUS EXTERIOR DETAILS	Do Do

THIS DRAWING APPLIES TO BUILDING NO. 1048.

WILBUR WATSON AND ASSOCIATES
ARCHITECTS AND ENGINEERS
Cleveland, Ohio
Cleveland, Ohio

CONSTRUCTION DIVISION
OFFICE OF THE QUARTERMASTER GENERAL
RAVENNA ORDNANCE PLANT
ADMINISTRATION AREA
FIRE HOUSE & QUARTERS
FOUNDATION GROUND & ROOF PLANS

SCALE: AS NOTED

REVISIONS:
1. CORRECTED
2. REVISED
3. REVISED

DATE: 6-10-41
PLAN NUMBER: 8984
1005201

APPROVED BY: R. S. CHAVIN [s]

DATE: 4/25/41
3/23/42

IA-48

THIS DRAWING NOT TO SCALE

THIS DRAWING TRACED FROM ORIGINAL PENCIL CONSTRUCTION DRAWING.