


ROOF PLAN
SCALE = 1/8" = 1'-0"

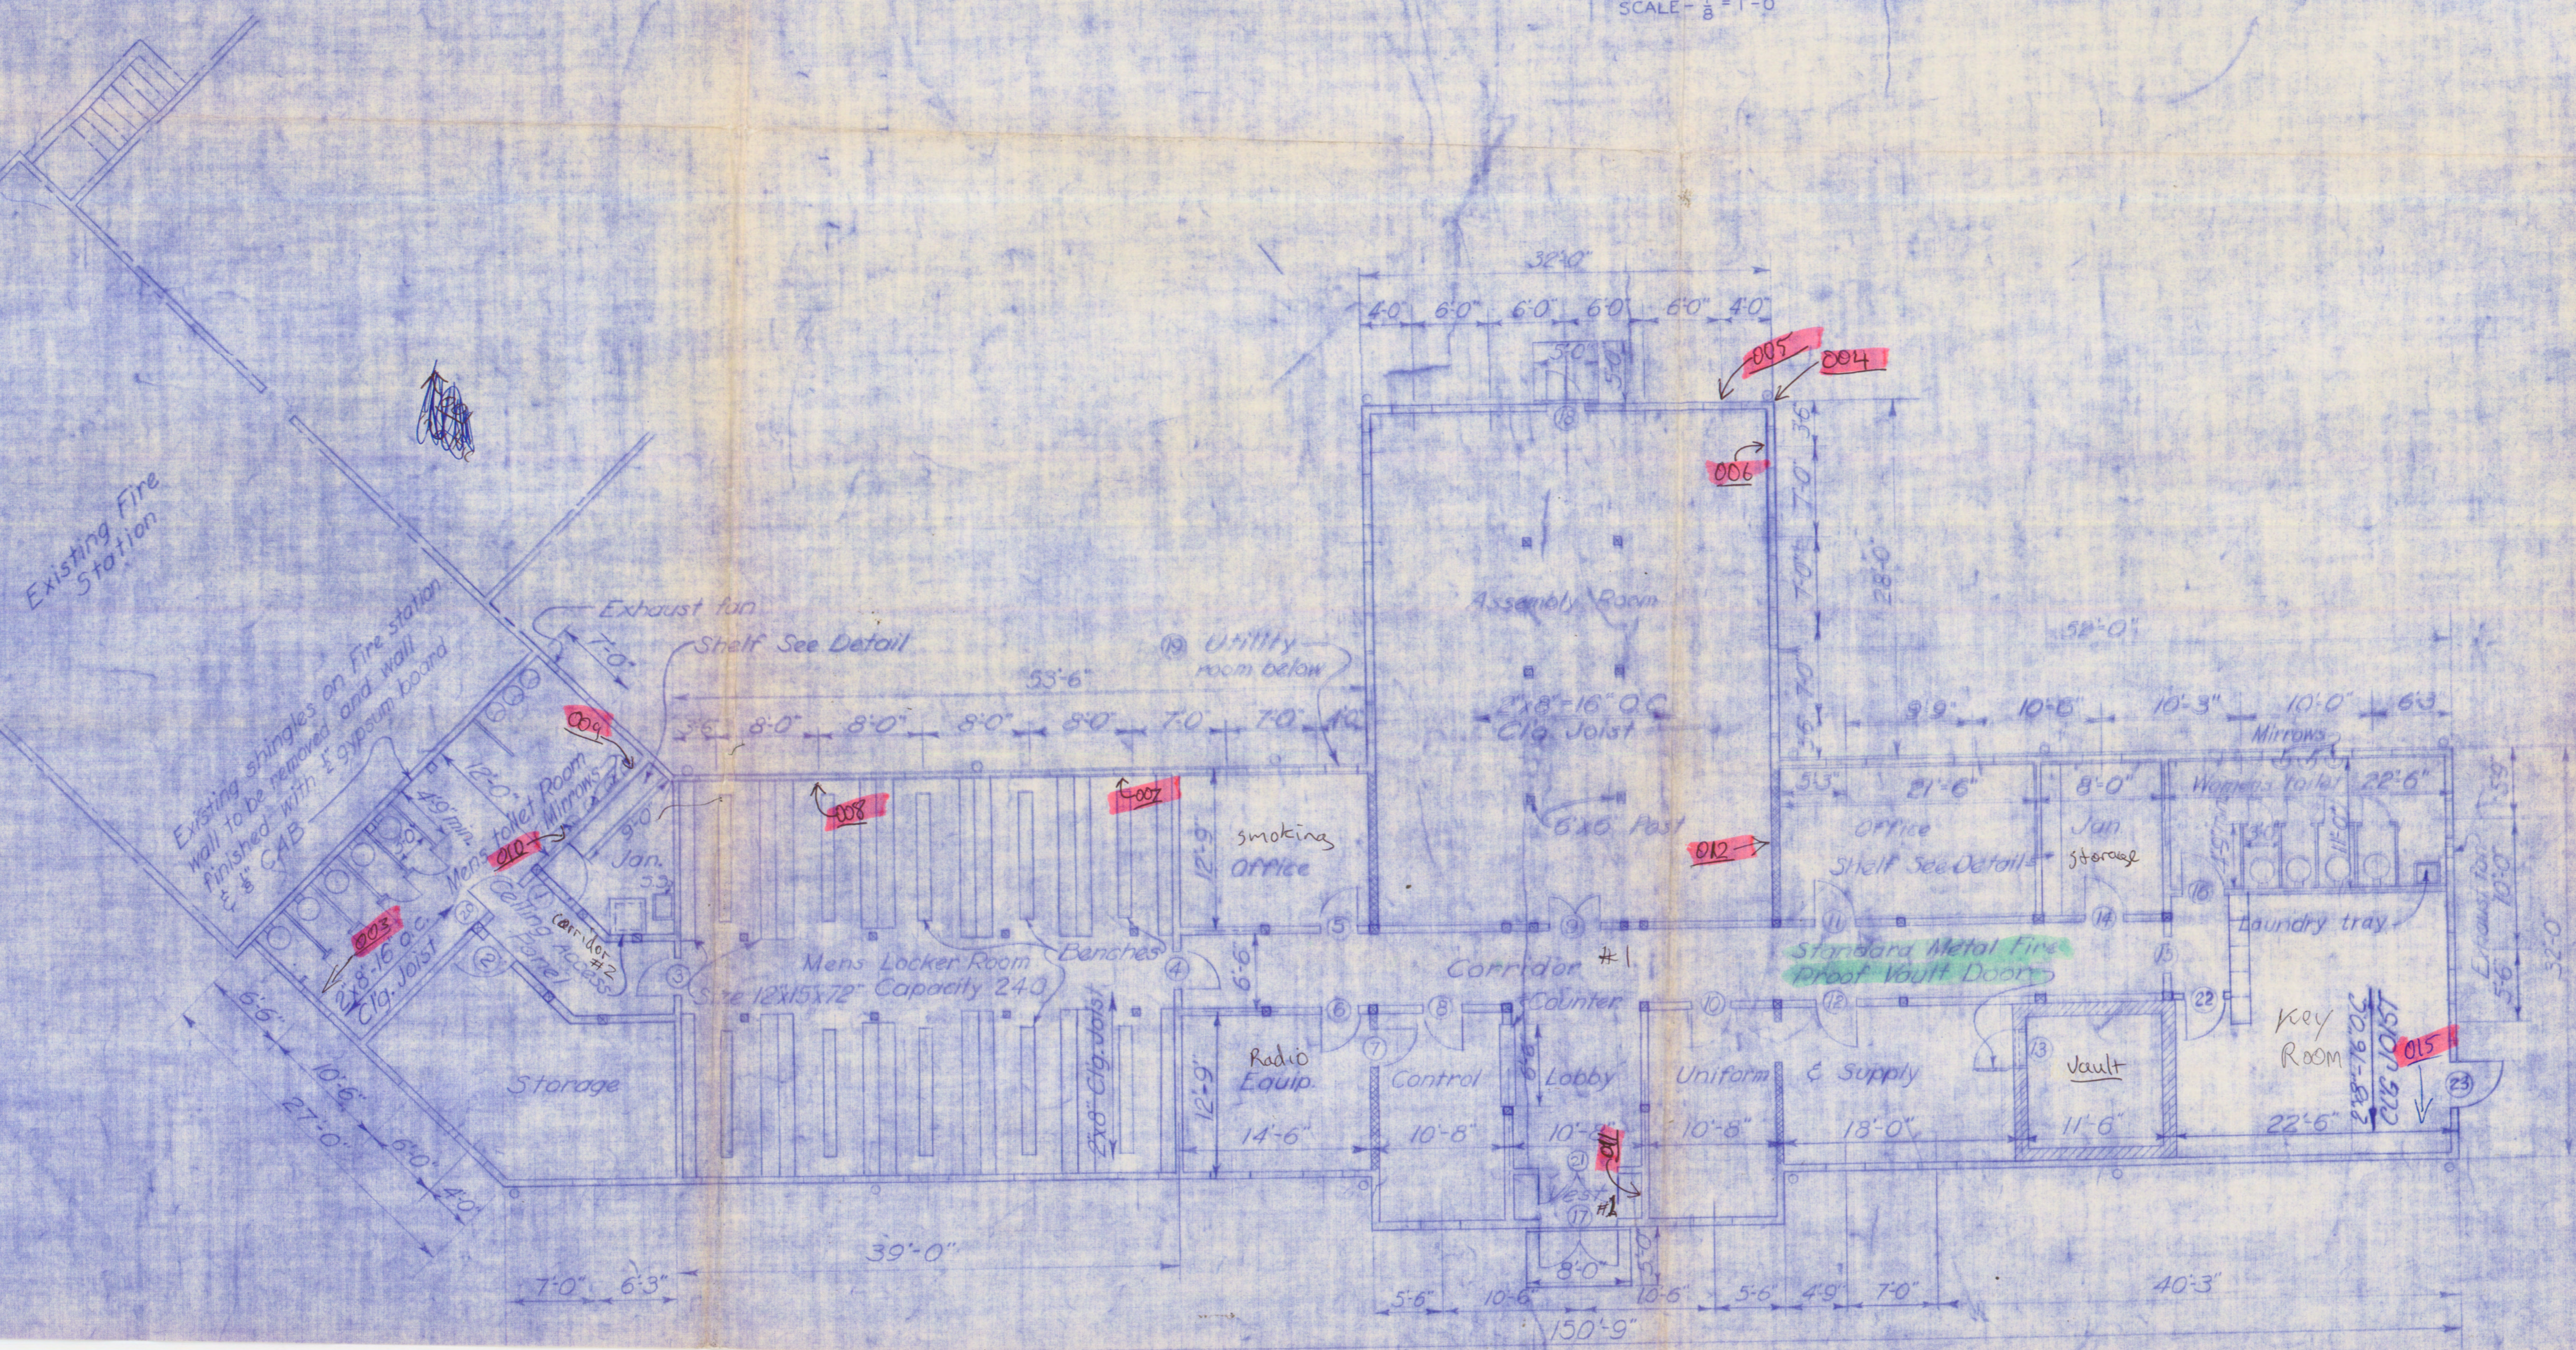

NOTES

For location plan, see Sh. No. 1
 For foundation plans and details, see Sh. No. 2
 For elevations, see Sh. No. 4
 For sections and details, see Sh. No. 5
 For door details and schedule, see Sh. No. 6
 For electrical & mechanical details see Sh. No.

1048
1048A

- ① FOR DETAILS OF ORIGINAL BLDG. FIRE HOUSE TO SEE DWGS. 1005-201, 202, 401, 501.
- ② FOR DETAILS OF 1969 ADDITION, BLDG. 1048-B, AMBU GARAGE, SEE C.O.E. DWGS. 87-01-08 SHTS. G-9, A-3, M.

REVISION	DATE	DESCRIPTION
	9-28-53	REVISED AS CONSTRUCTED
CORPS OF ENGINEERS U. S. ARMY OFFICE OF THE DISTRICT ENGINEER HUNTINGTON, W. VA.		
RAVENNA ARSENAL APCO, OHIO GUARD QUARTERS FLOOR AND ROOF PLANS		
DRAWN BY:	W.E.L.	
TRACED BY:	W.E.L.	
CHECKED BY:	H.F.K. H.G.H.	