

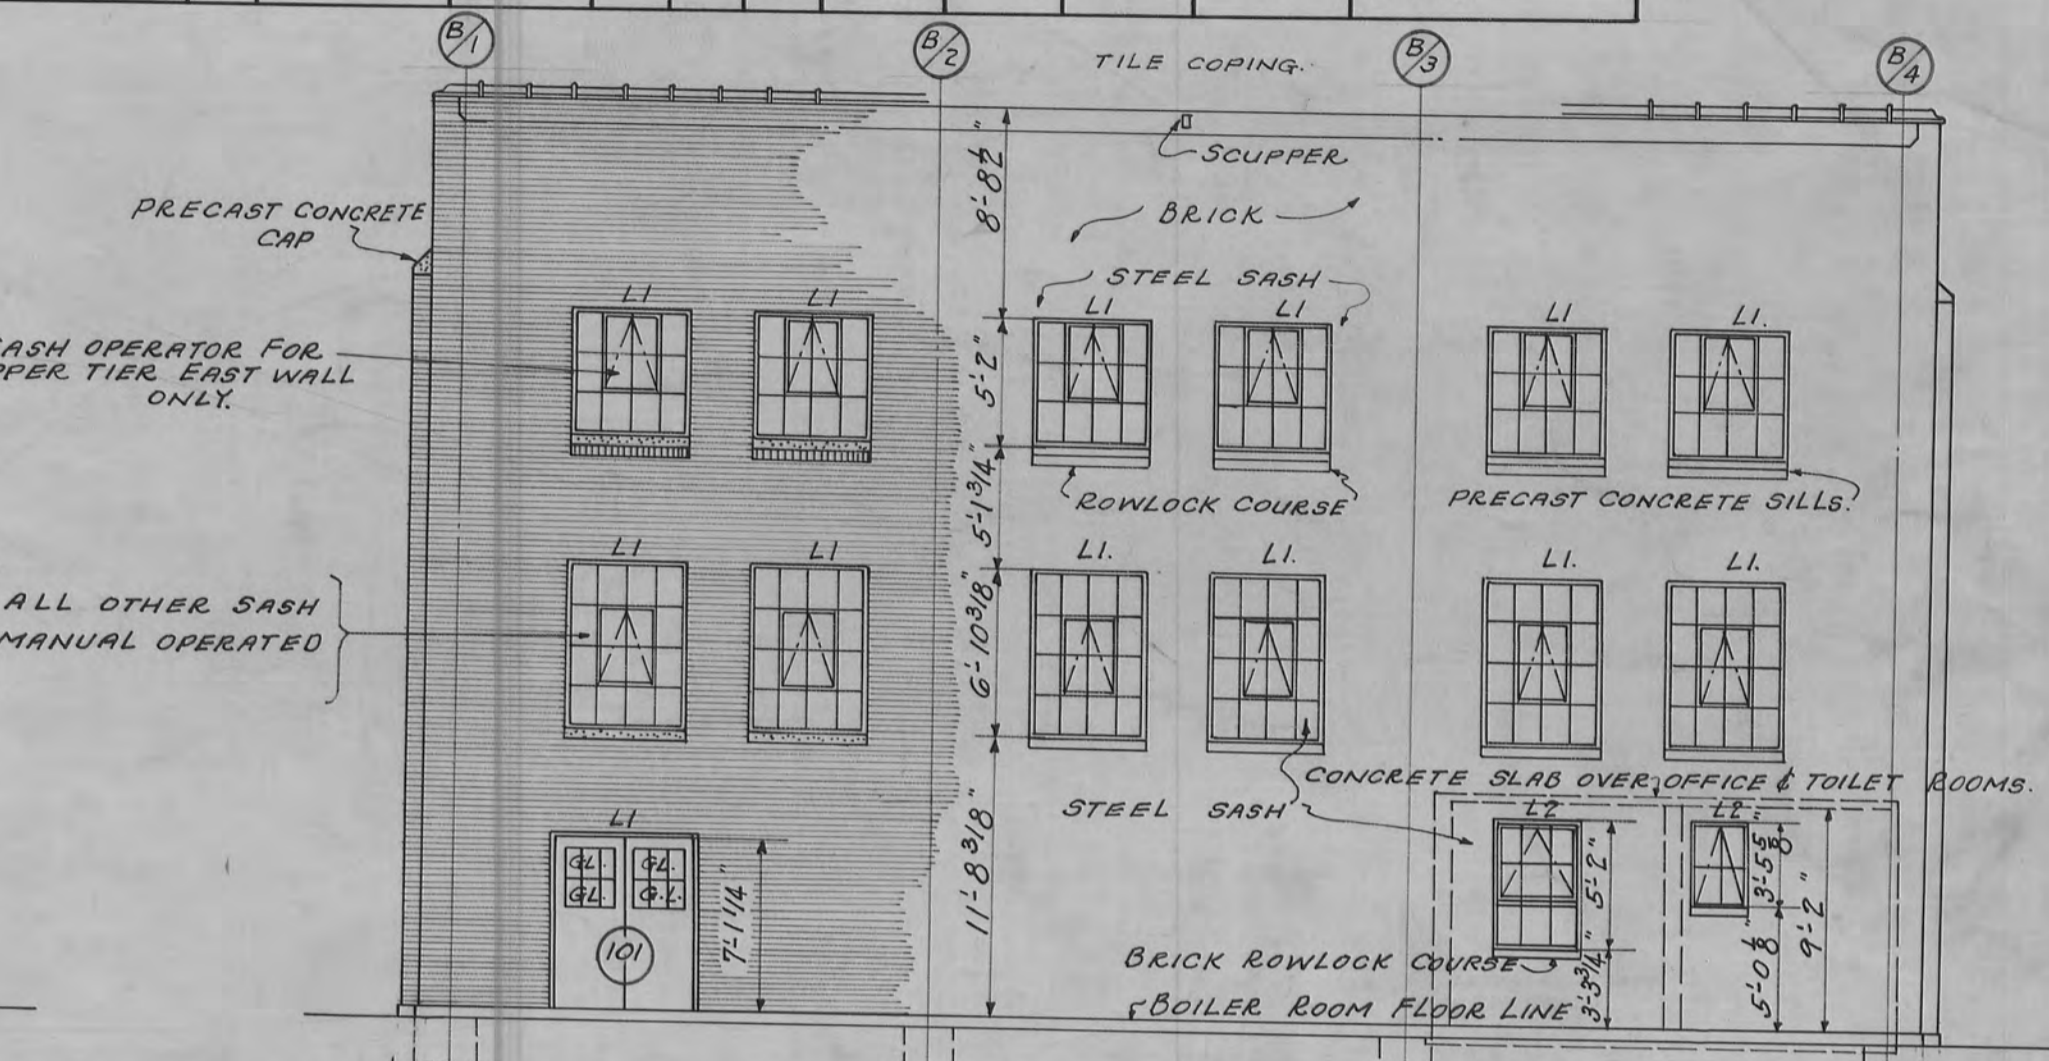
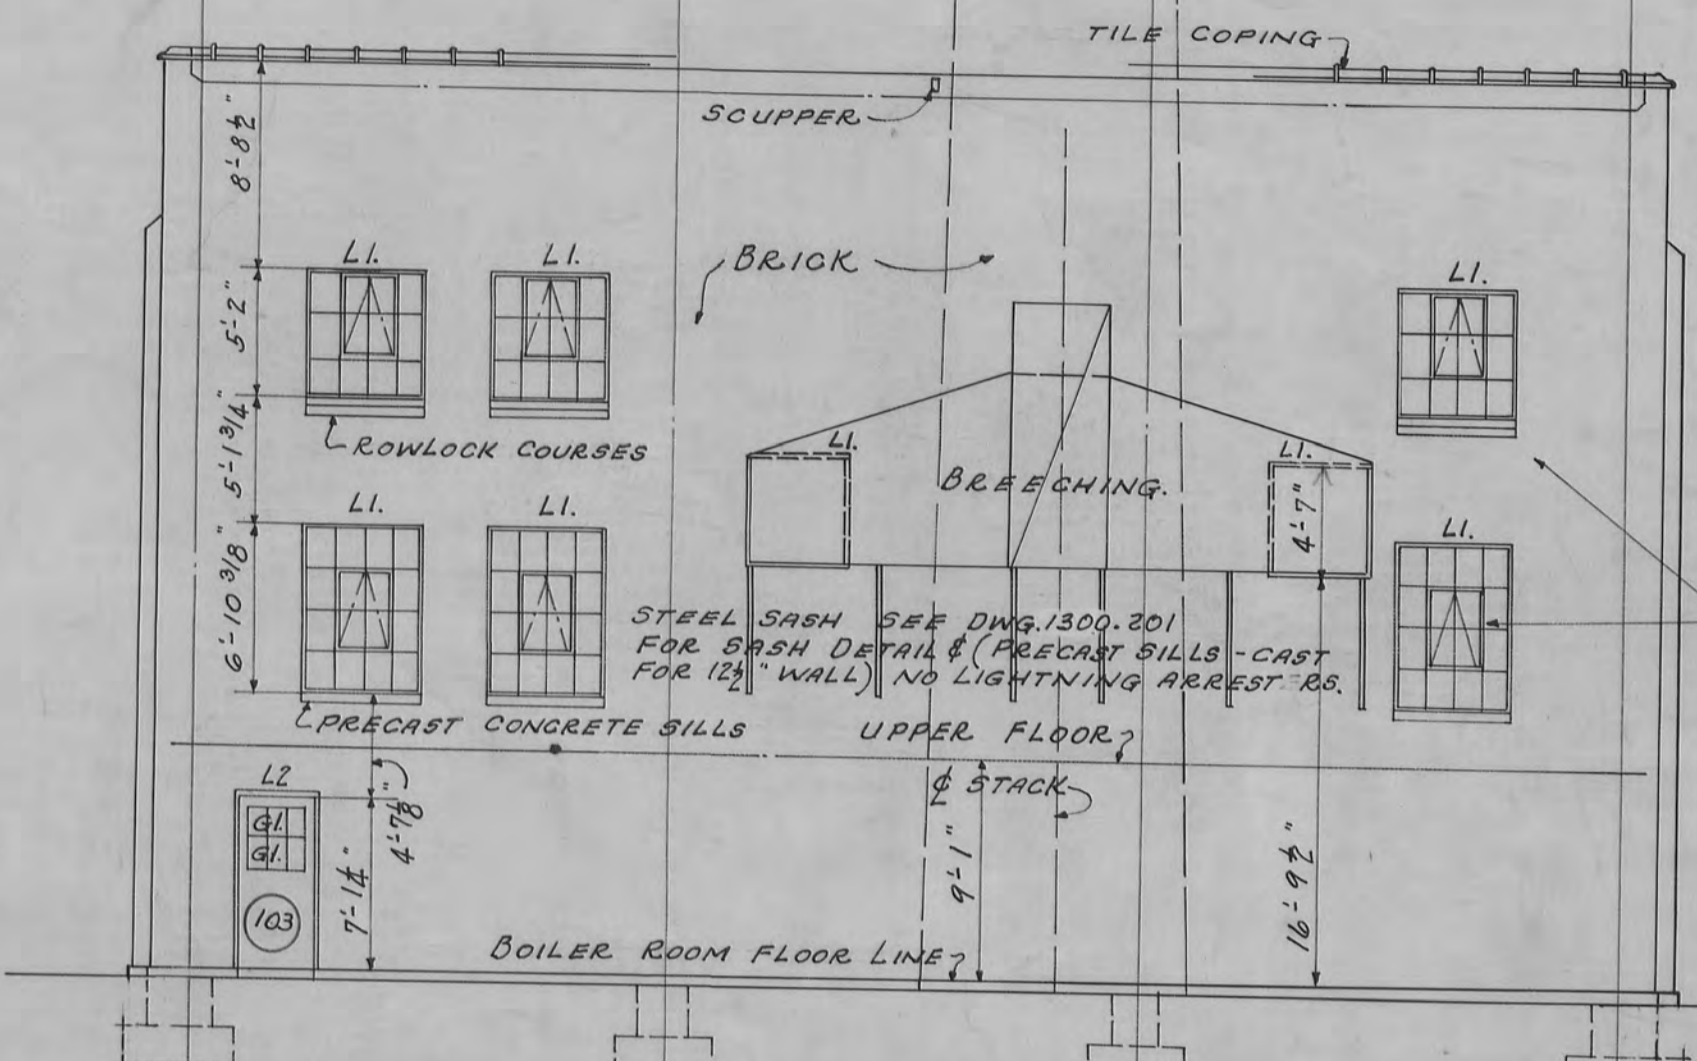
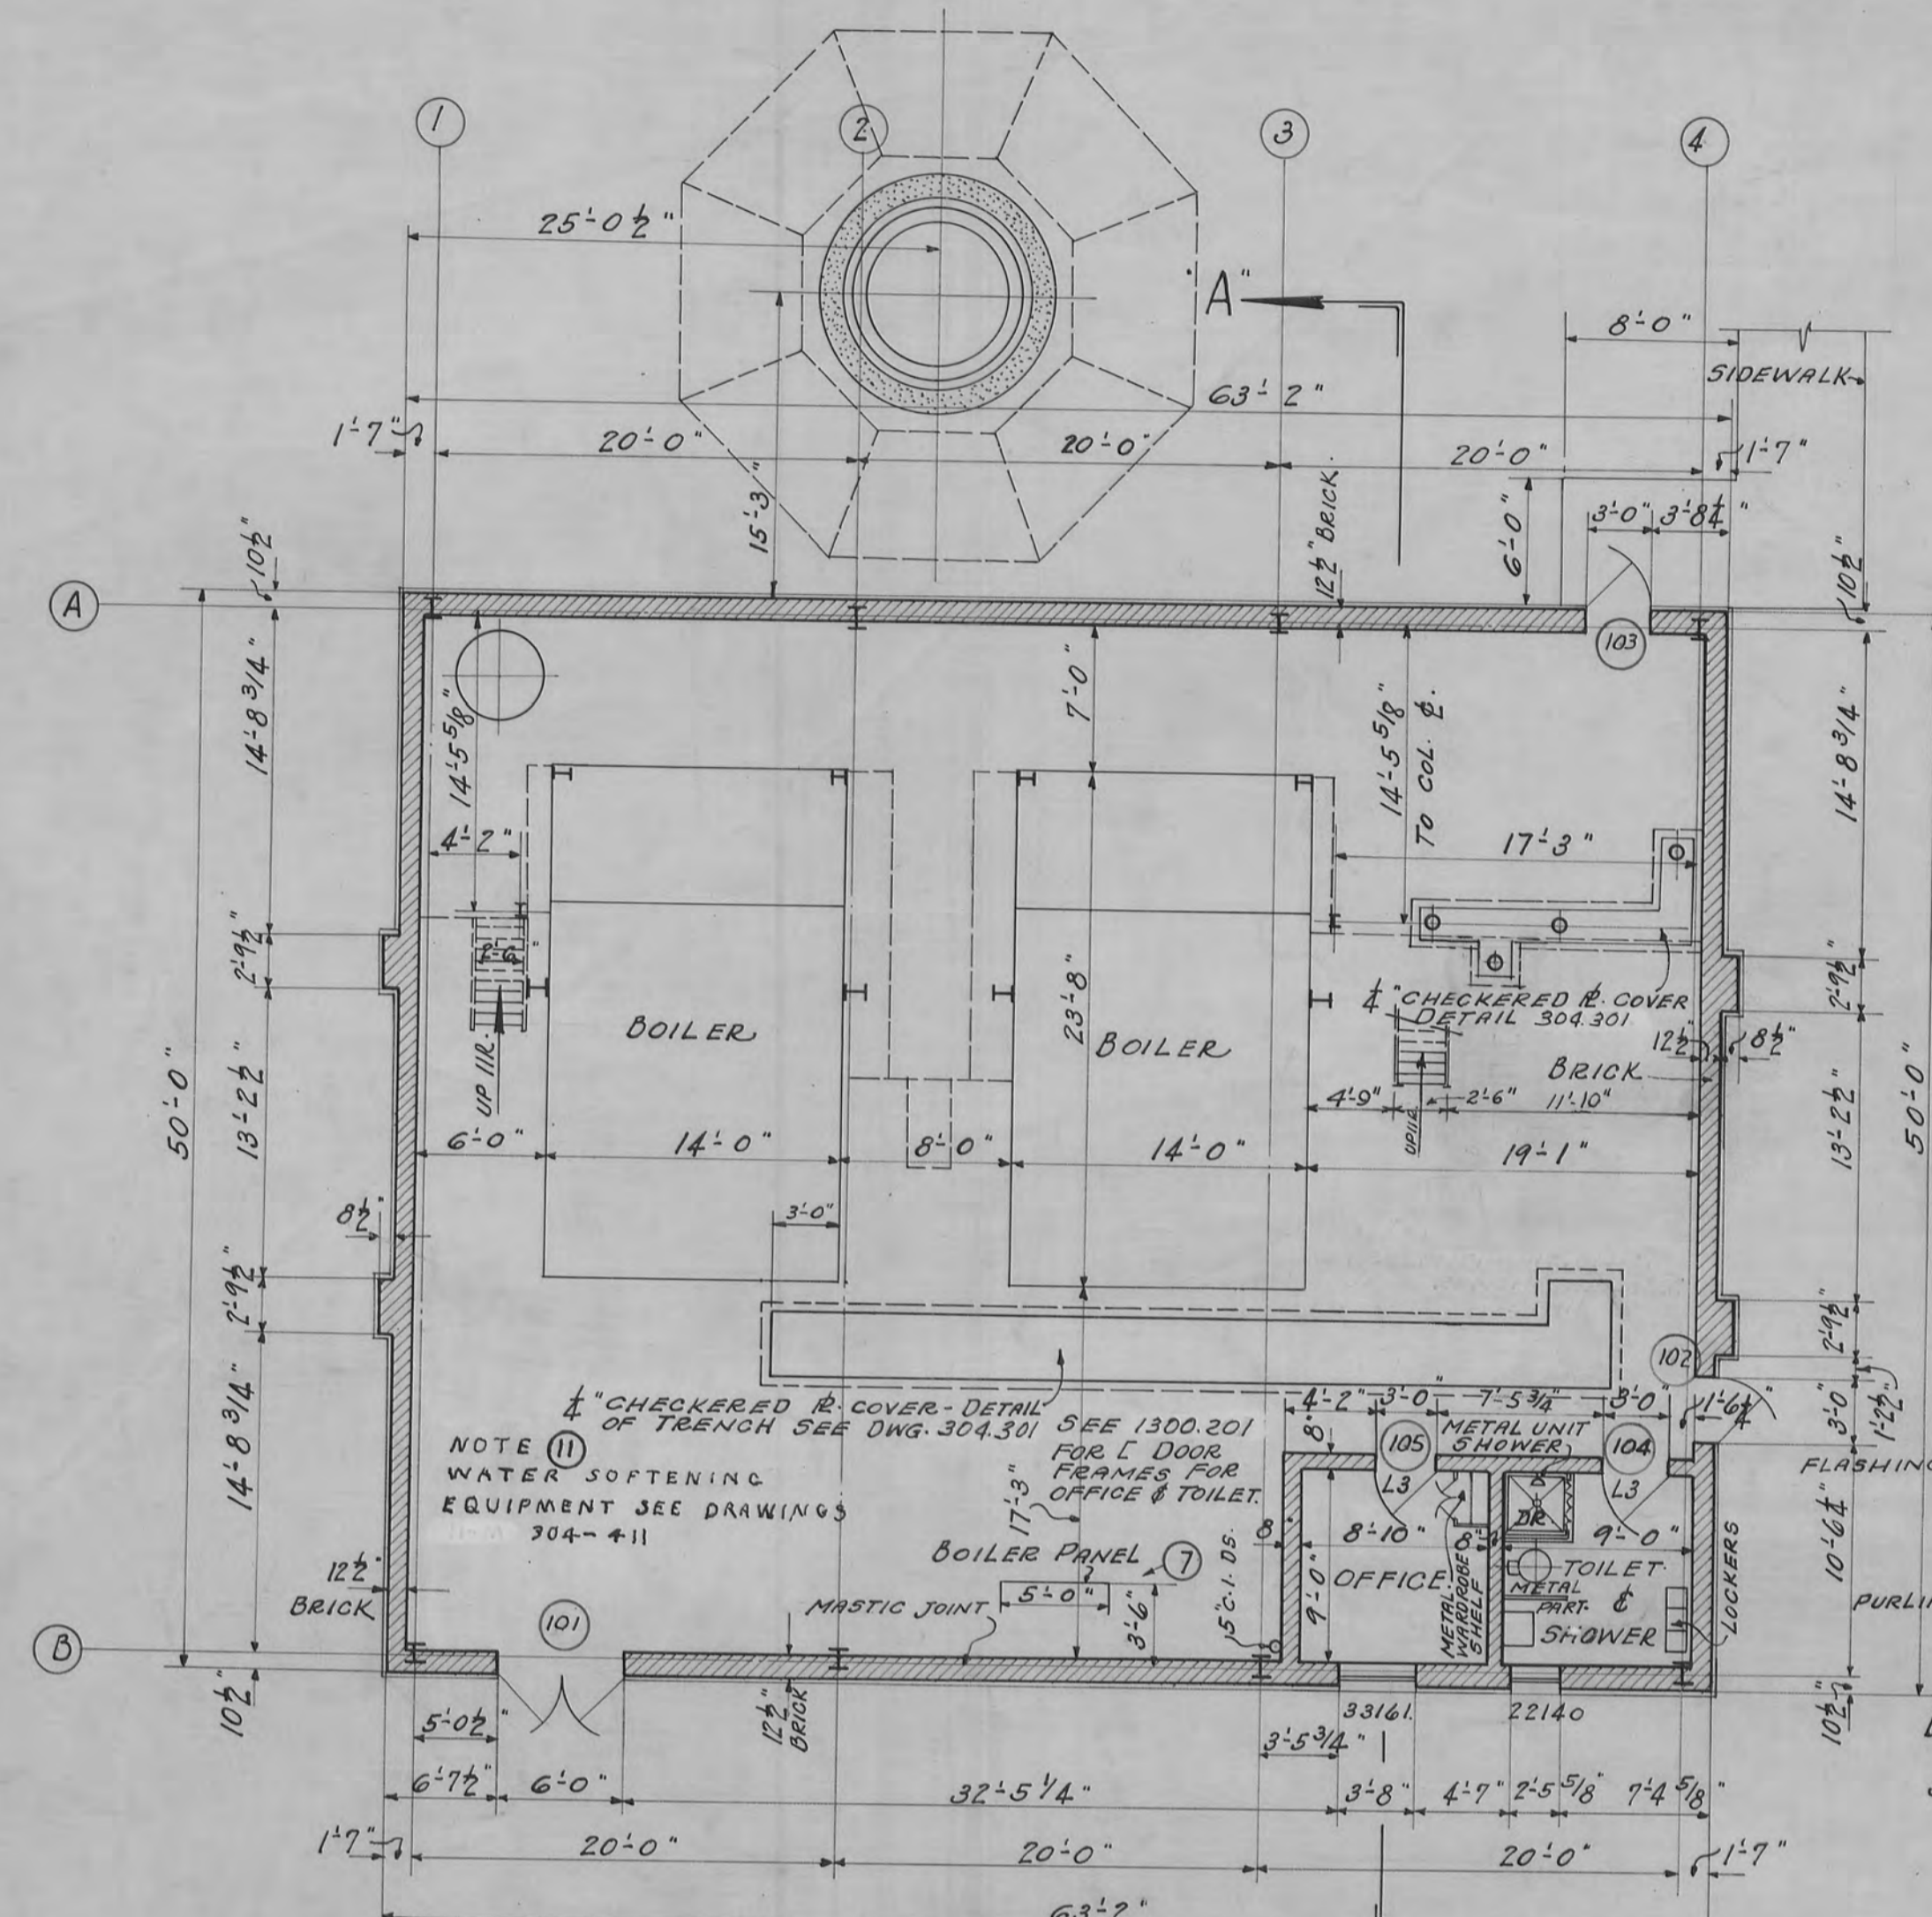
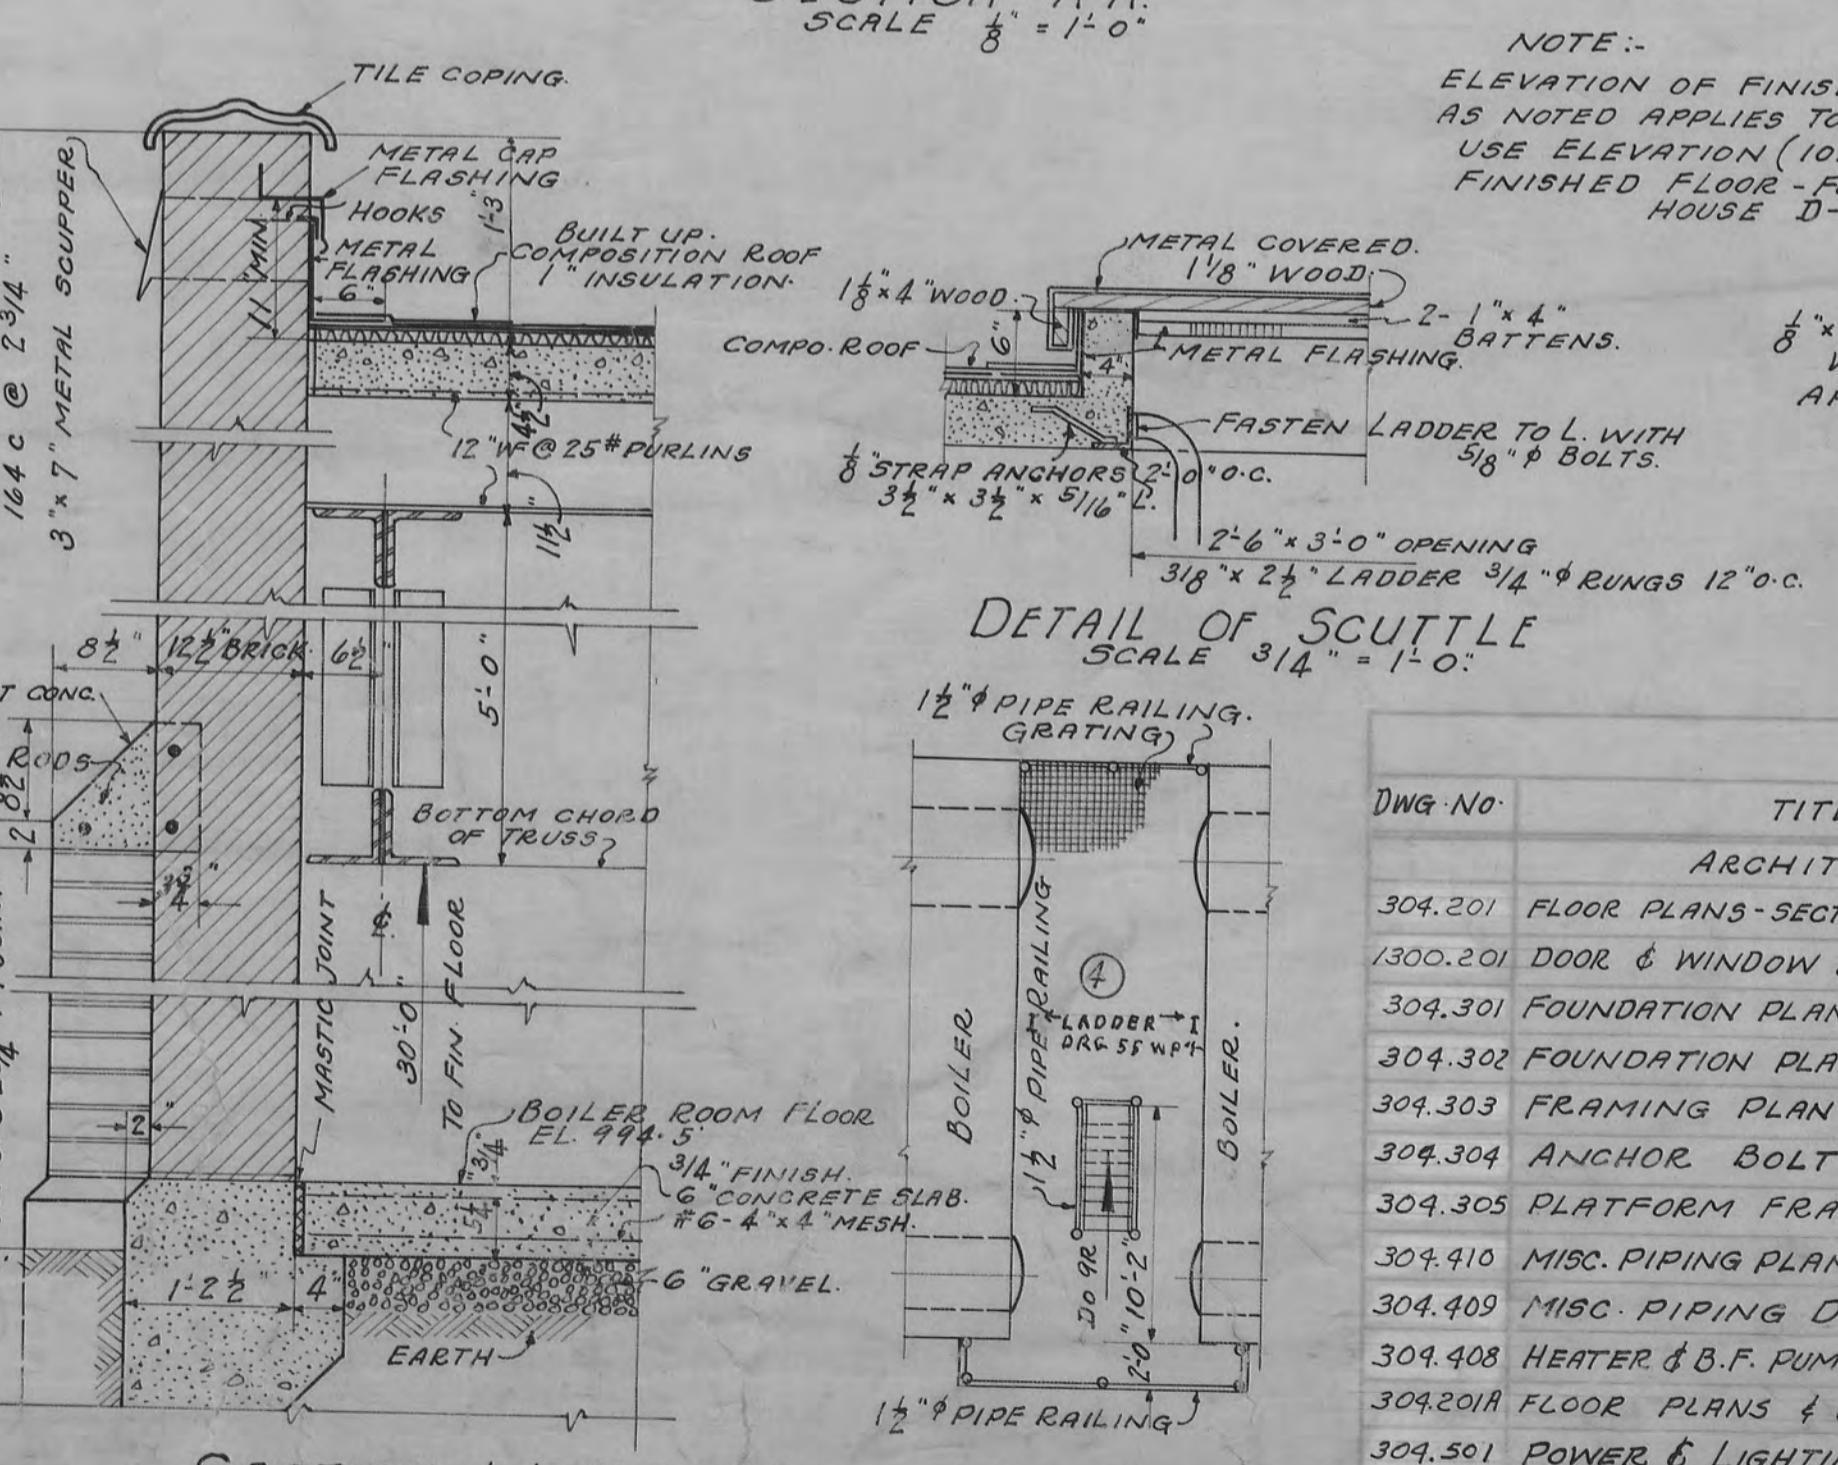
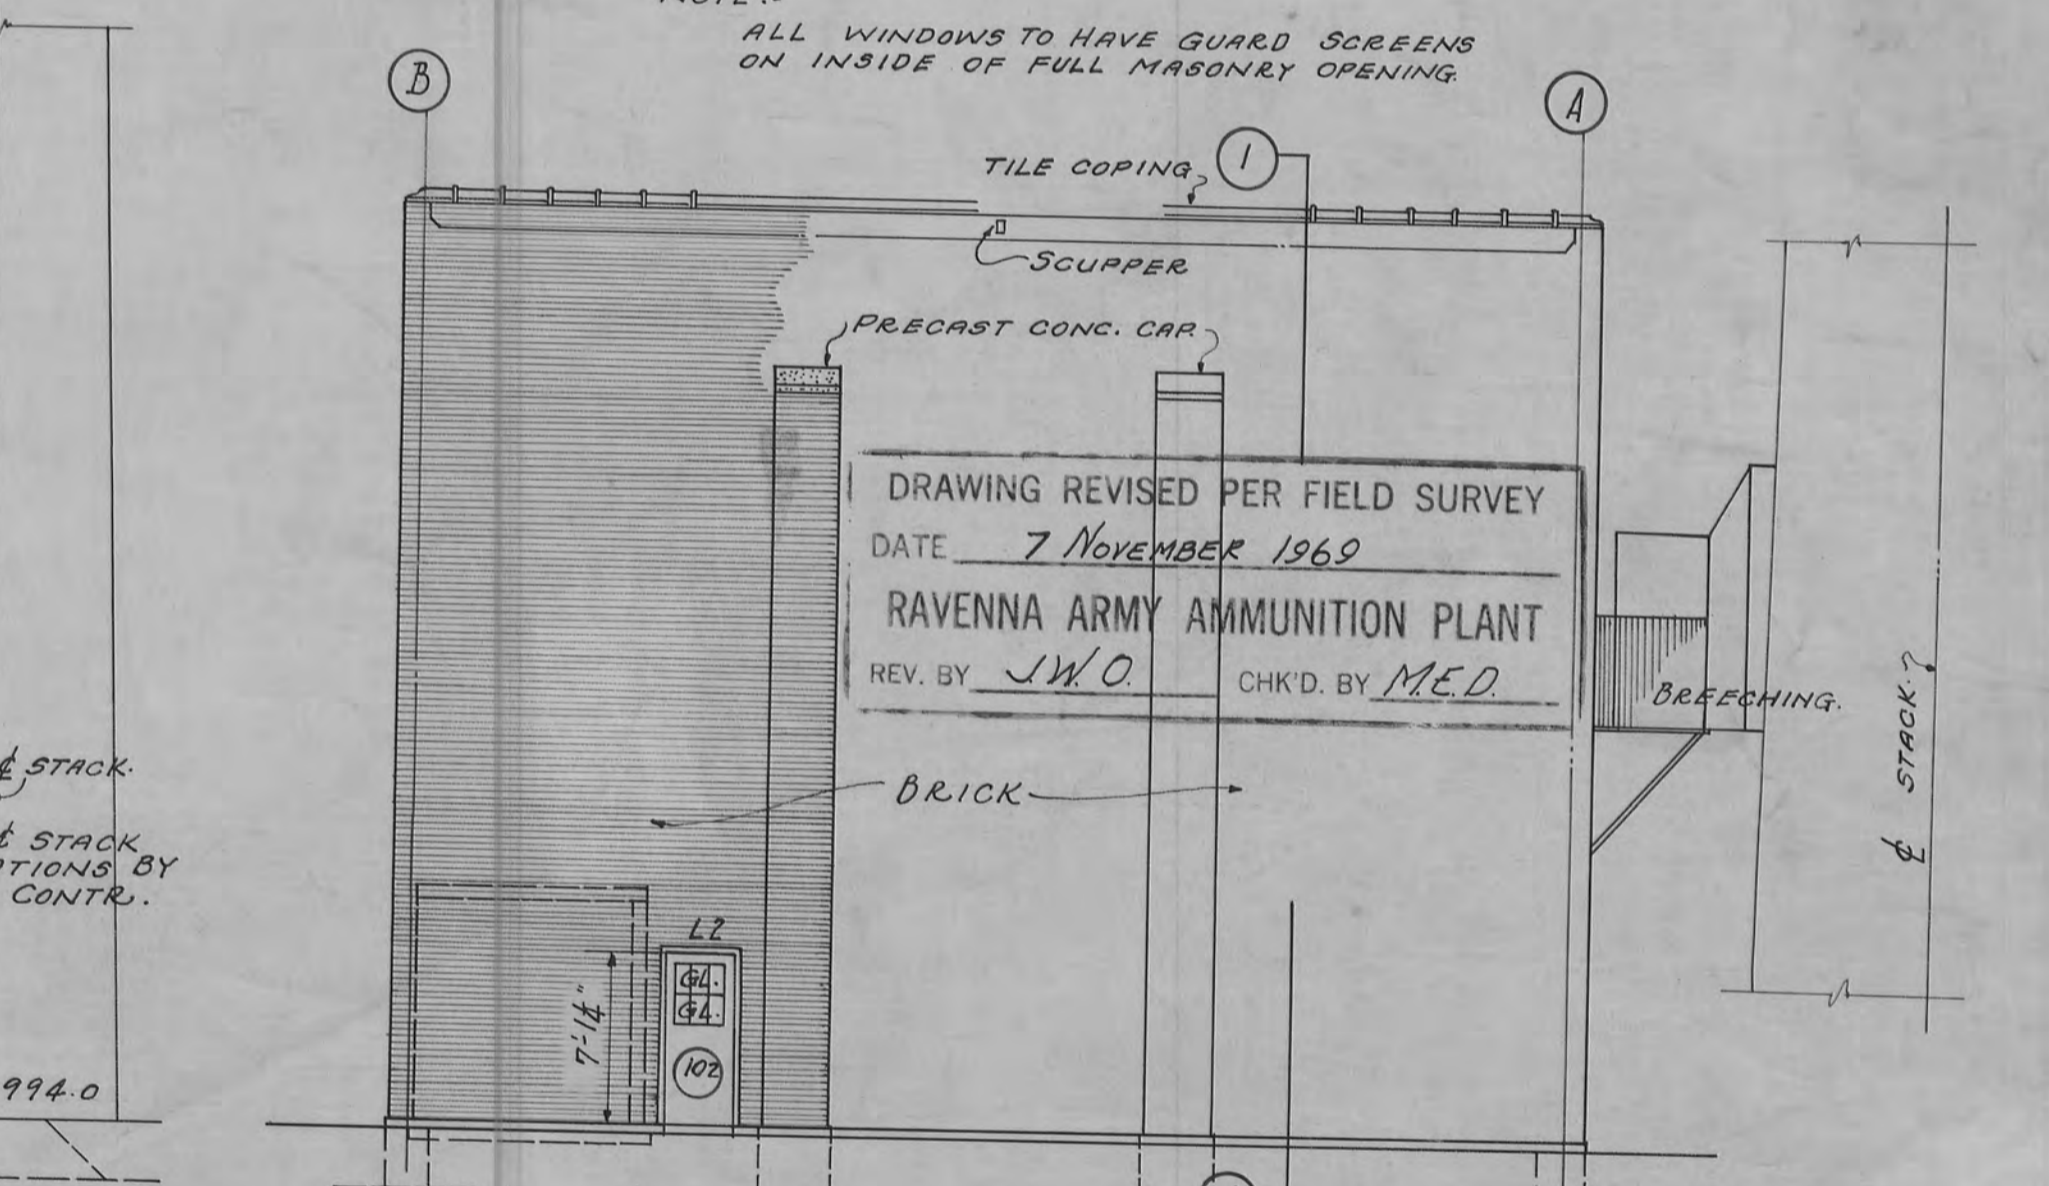


DOOR SCHEDULE											
DOOR NUMBER	TYPE	MASONRY OPENING	WALL THICKNESS	DOORS WIDE	DOORS HIGH	DOORS THICK	MATERIAL	FRAME & TRIM	THRESHOLD	LINTEL	REMARKS
101	D		12" BRICK	2'-0"	7'-0"	2" PL	METAL CLAD	BENT PLATE	NONE	2'-0" x 3/4"	DET. ON THIS DWG.
102 & 103	M		do	do	do	do	do	do	do	2'-0" x 3/4"	do
104 & 105	M		8" BRICK	do	do	do	do	do	do	8" x 11.5"	DET. ON

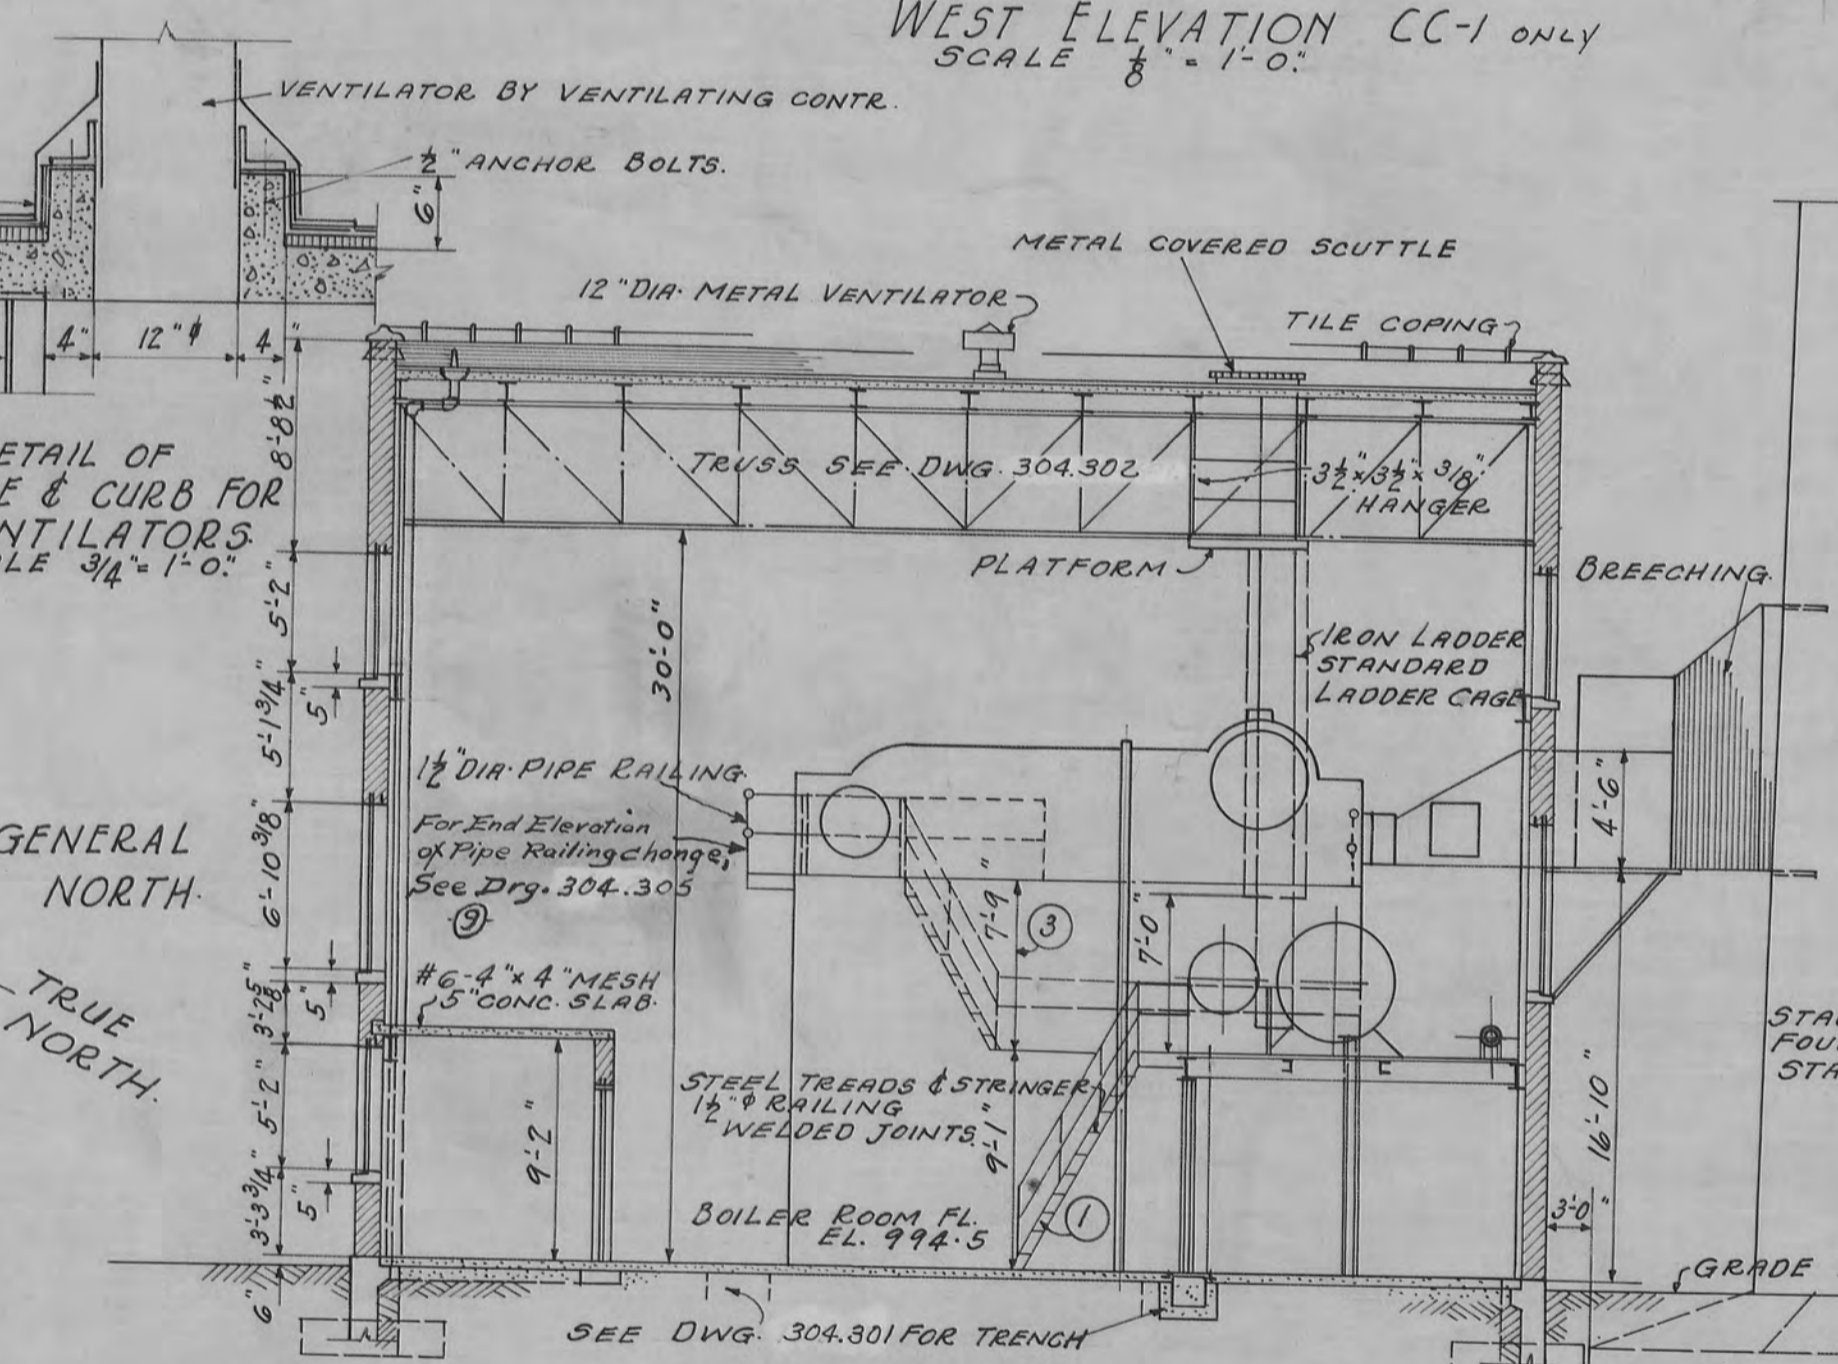

LINTEL SCHEDULE

L1- 3'-4" x 3 1/2" x 5/16" J.L.
L2- 3'-3 1/2" x 3 1/2" x 5/16" J.L.
L3- 2'-3 1/2" x 3 1/2" x 5/16" J.L.

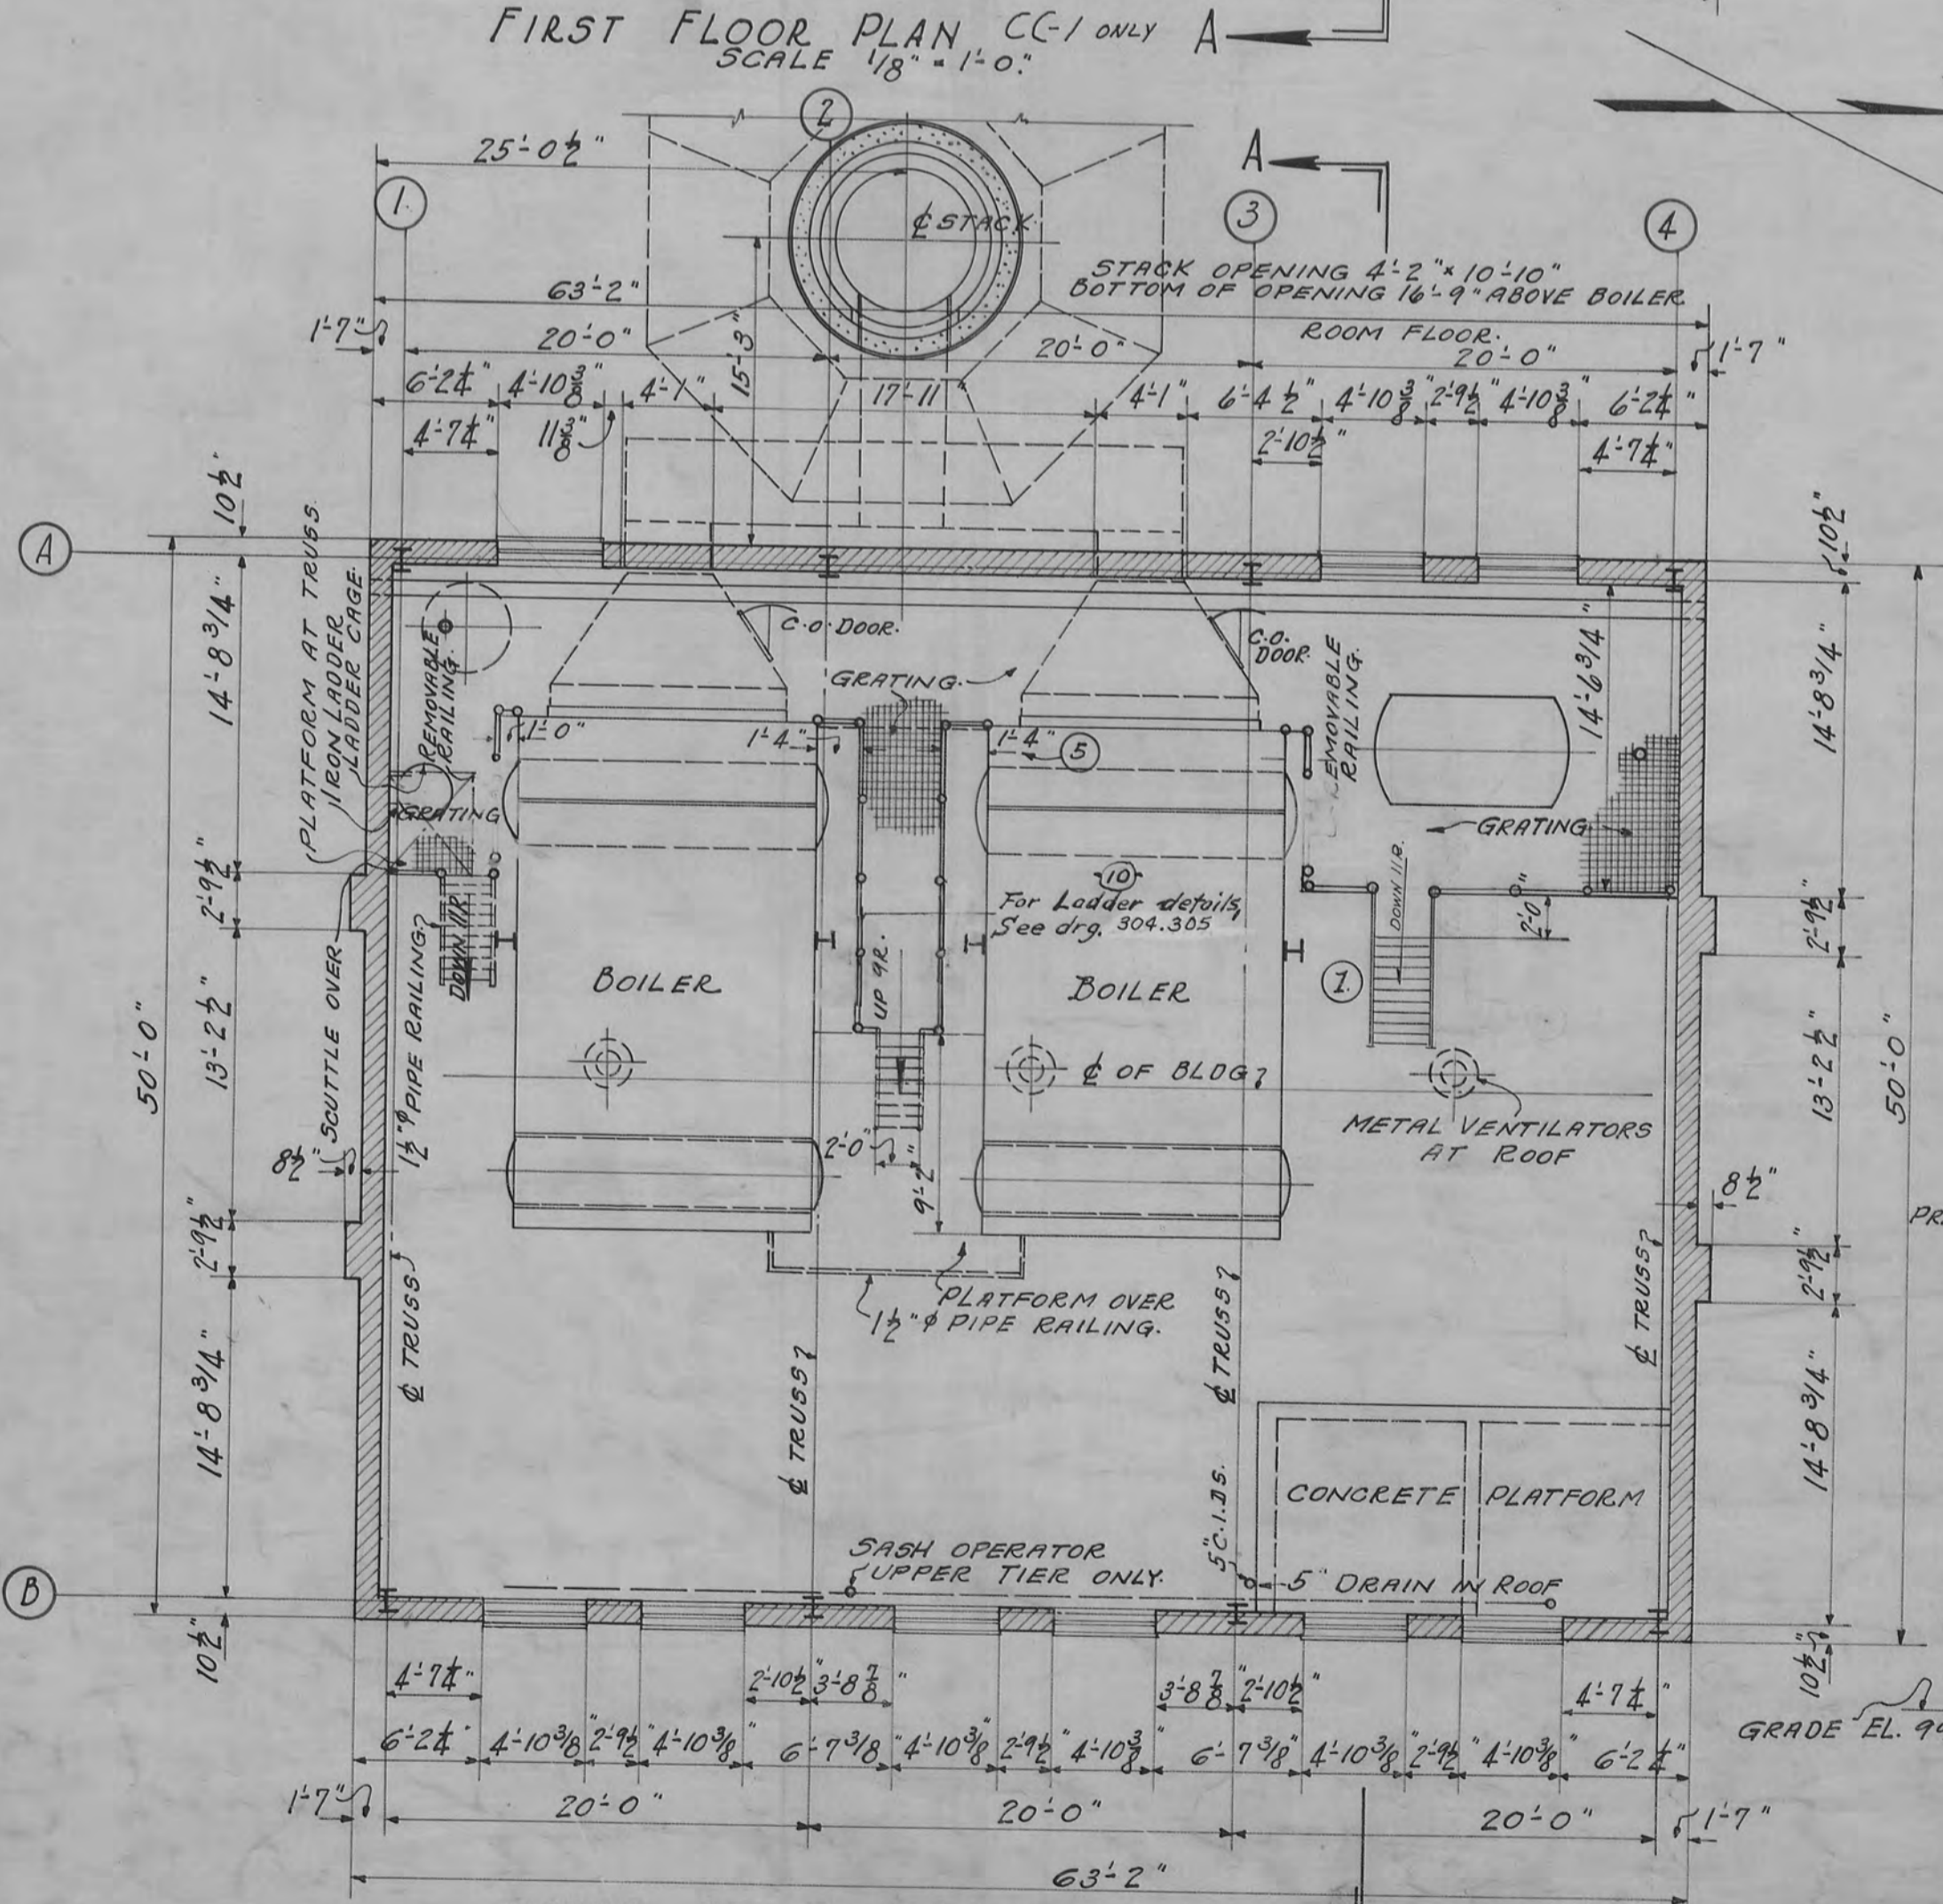

DWG NO.	TITLE	APPLIES TO	NOTES
304.201	FLOOR PLANS-SECTION-ELEVATIONS	CC & DC.	
1300.201	DOOR & WINDOW DETAILS	CC & DC.	
304.301	FOUNDATION PLANS & DETAILS	CC.	
304.302	FOUNDATION PLANS & DETAILS	DC	
304.303	FRAMING PLAN & DETAILS	CC & DC	
304.304	ANCHOR BOLT PLAN	CC & DC.	
304.305	PLATFORM FRAMING	CC & DC	
304.910	MISC. PIPING PLANS-ELEV. SECT.	CC & D.C.	
304.909	MISC. PIPING DETAILS	CC & DC.	
304.908	HEATER & B.F. PUMP PIPING DET.	CC & DC.	
304.201A	FLOOR PLANS & ELEVATIONS	DC	
304.501	POWER & LIGHTING LAYOUT	CC & DC.	
304.201A	FLOOR PLANS & ELEVATIONS	DC	

NOTE: SEE PLAN FOR STAIR WIDTHS.

THE FLOOR PLANS, ELEVATIONS, & SECTION H1 ARE FOR CC-1 ONLY. SEE DWG. 304.201-A FOR PLANS DC-1.

WILBUR WATSON AND ASSOCIATES
ARCHITECTS AND ENGINEERS
Cleveland, Ohio
Cleveland, Ohio

CONSTRUCTION DIVISION
OFFICE OF THE QUARTERMASTER GENERAL

RAVENNA ORDNANCE PLANT

LOAD LINE PLANS
BOILER HOUSE
CC-1 & DC-1
FLOOR PLANS - SECTION - ELEVATIONS
50'-0" x 63'-2" TYPE-1

SCALE 1/8" = 1'-0"

APPROVED BY: [Signature]

DATE: 5/28/41

PLAN NUMBER 6934

304.201