



EQUIPMENT INDEX			
1 SAND DRYER	5 AIR COMPRESSOR	6 STORAGE OIL PUMP	7 DIESEL OIL PUMP
2 SAND ELEVATING DRUM			
3 AIR RECEIVING TANK			
4 SUMP PIT. SEE DET 109-B			


DOOR SCHEDULE											
DOOR NUMBER	TYPE	MAJONAY OPING	WALL THICKNESS	WIRE	GLASS THICK	MATERIAL	FRAME	THRESHOLD	GLAZING	LINTEL	REMARKS
100	A	5'11 1/2" x 7'4"	8"	3"	7 1/2"	1 1/2"	WD	WD	NONE	WIRE GL	2 3/4" x 4 1/2" x 3"
101	G	5'11 1/2" x 7'4"	DO	3"	7 1/2"	2 1/2"	DO	DO	DO	DO	2 3/4" x 3 1/2" x 3"
102	E	5'5 1/2" x 7'4"	DO	3"	7 1/2"	1 1/2"	DO	DO	DO	DO	

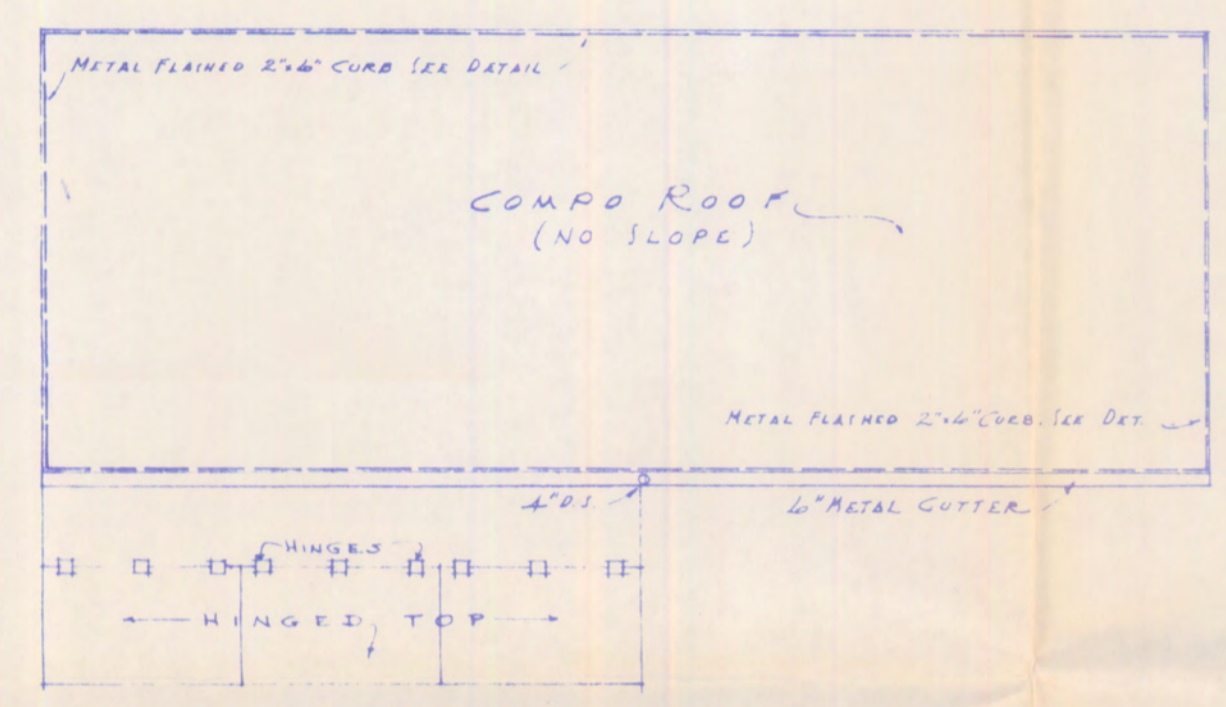


ROOF PLAN  
SCALE 1/8" = 1'-0"

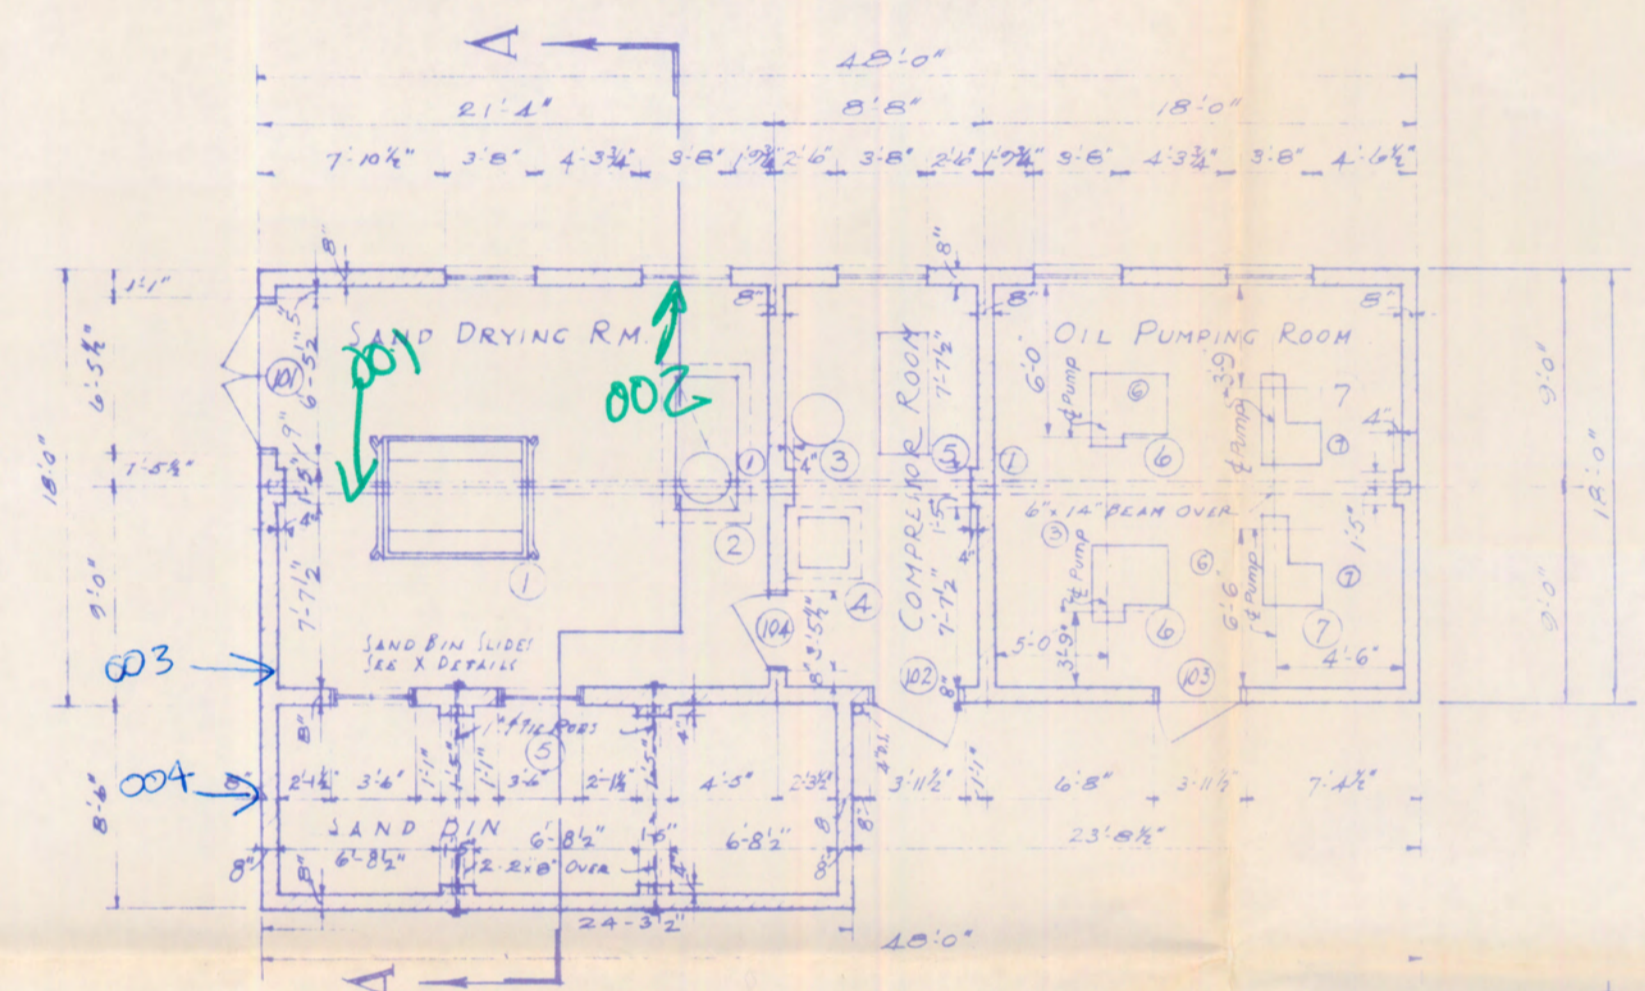


FLOOR PLAN  
SCALE 1/8" = 1'-0"

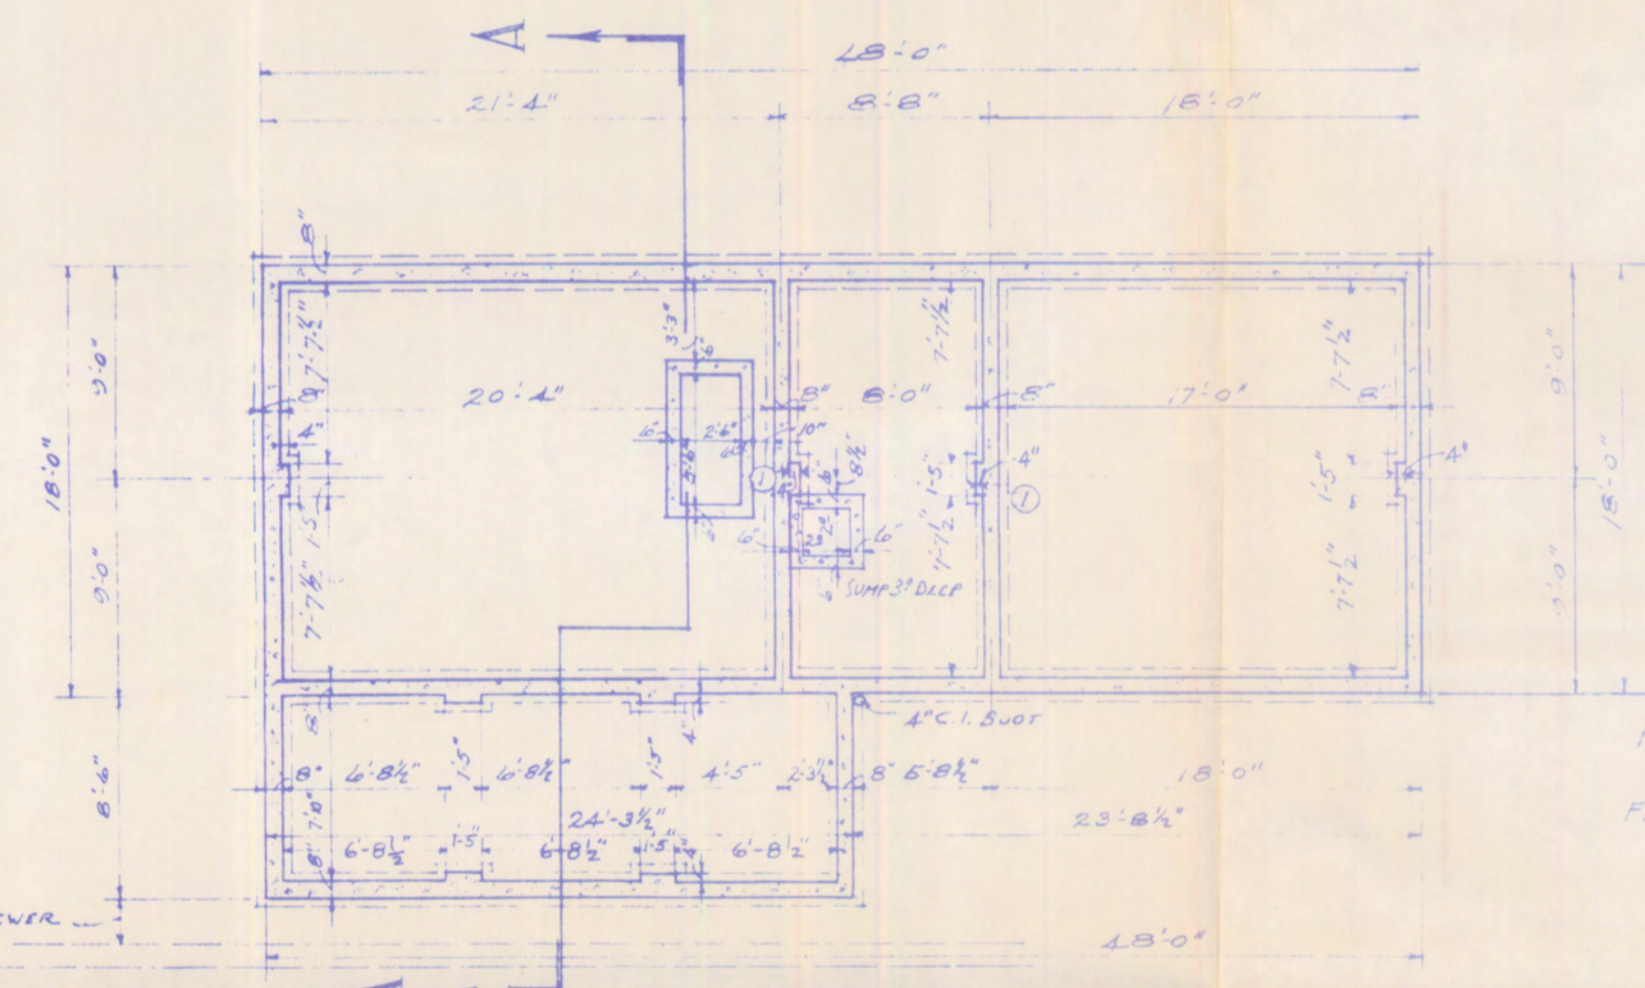


FOUNDATION PLAN  
SCALE 1/8" = 1'-0"

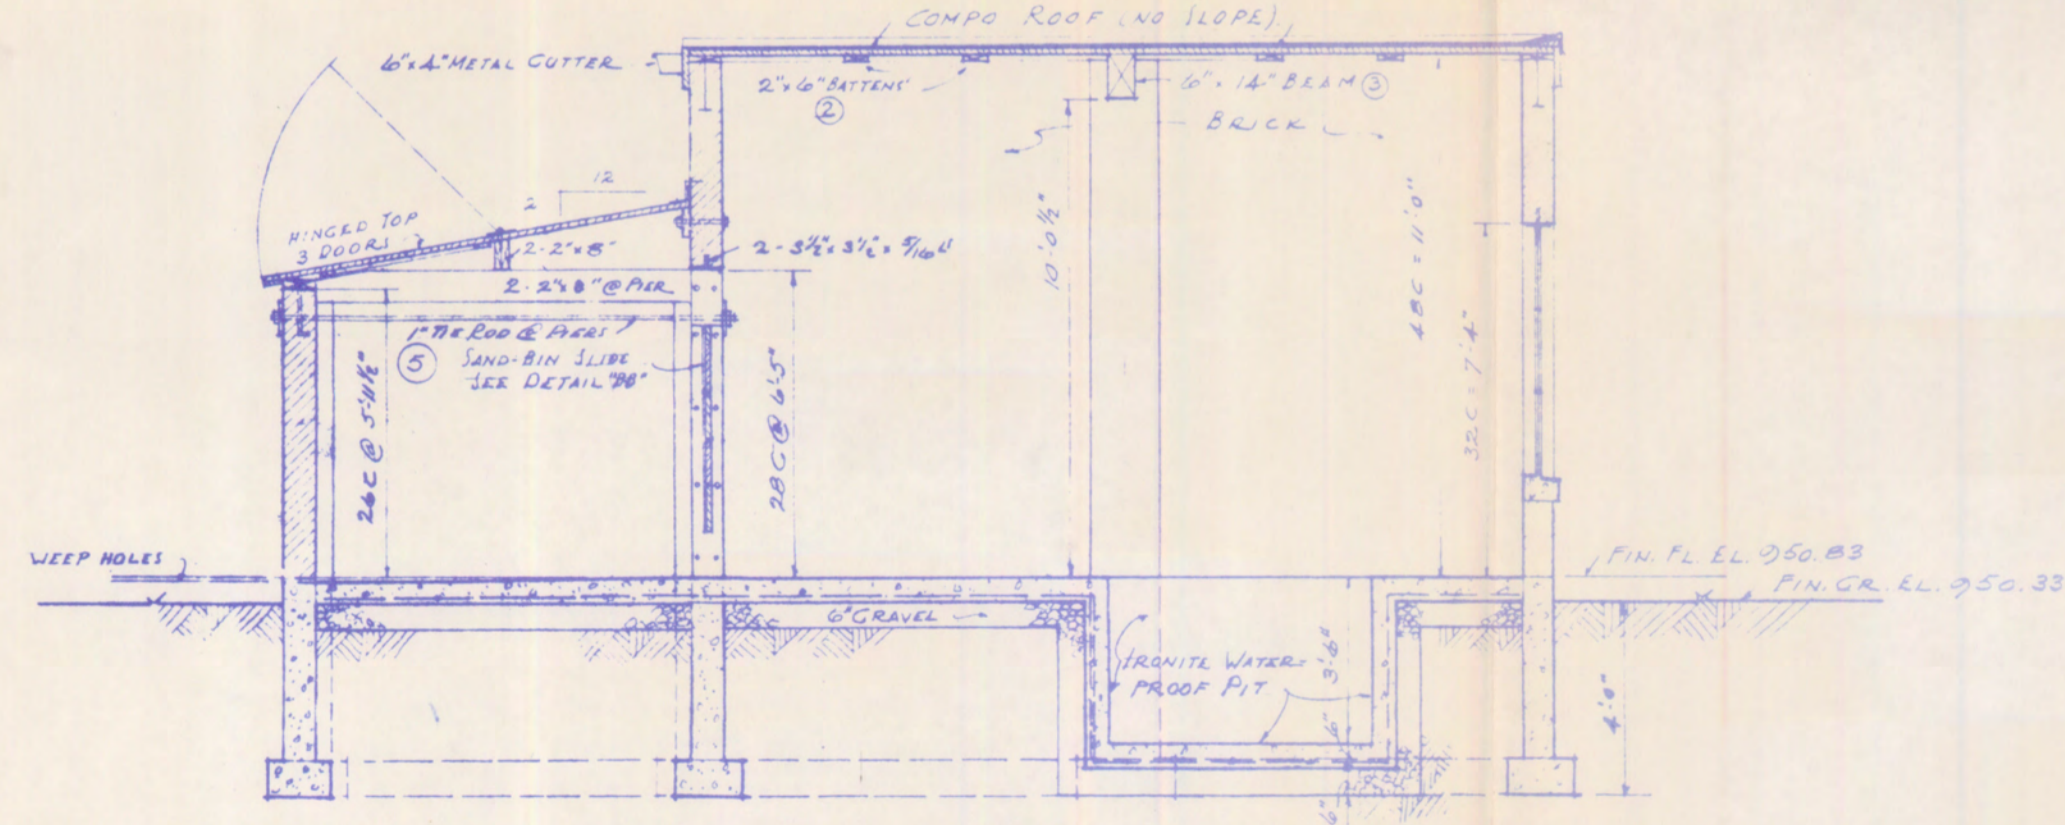


SECTION "A-A"  
SCALE 1/4" = 1'-0"

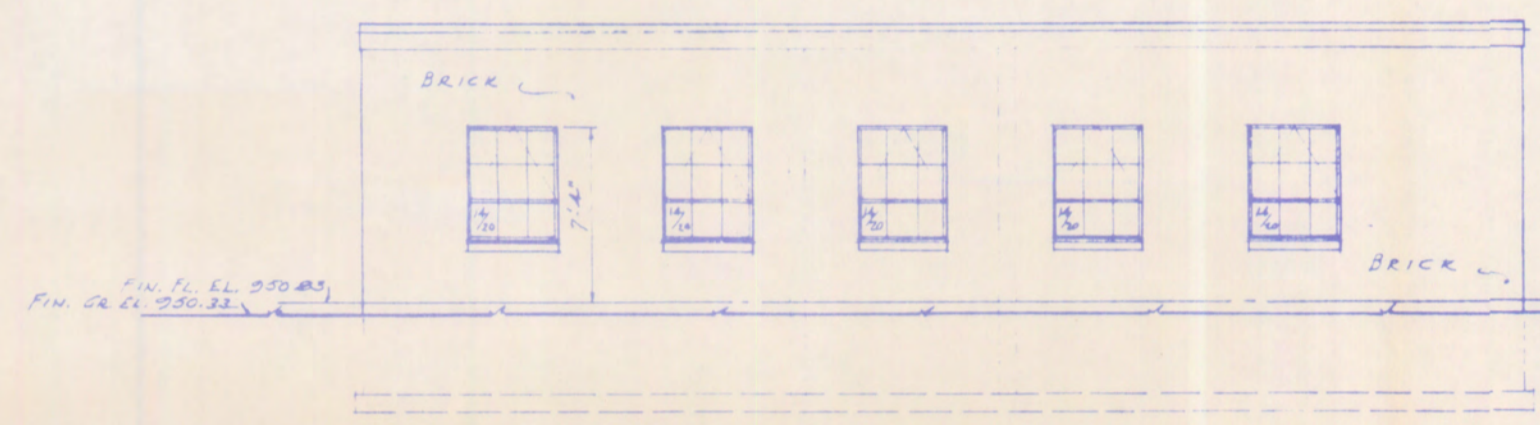


WEST ELEVATION  
SCALE 1/8" = 1'-0"

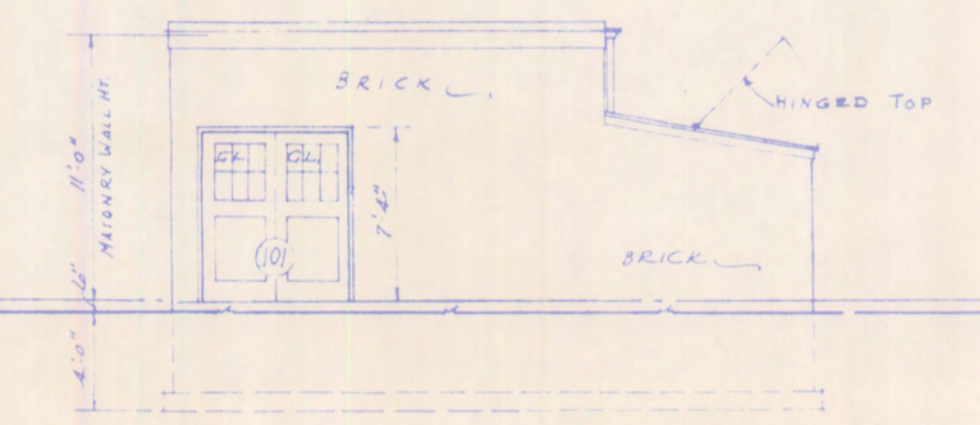


SOUTH ELEVATION  
SCALE 1/8" = 1'-0"

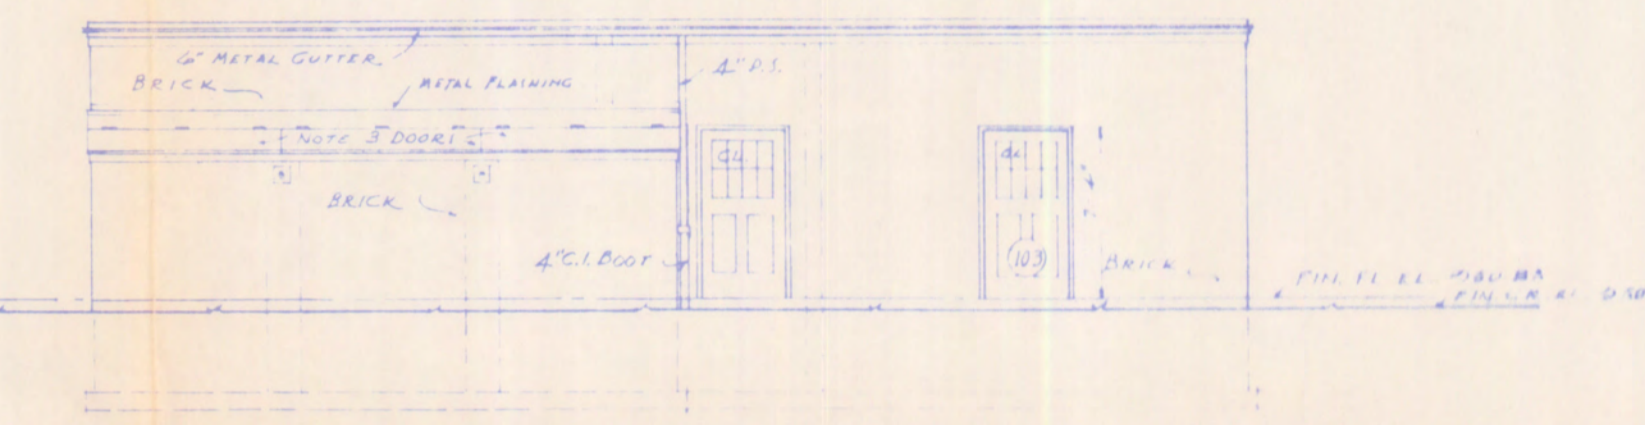


EAST ELEVATION  
SCALE 1/8" = 1'-0"

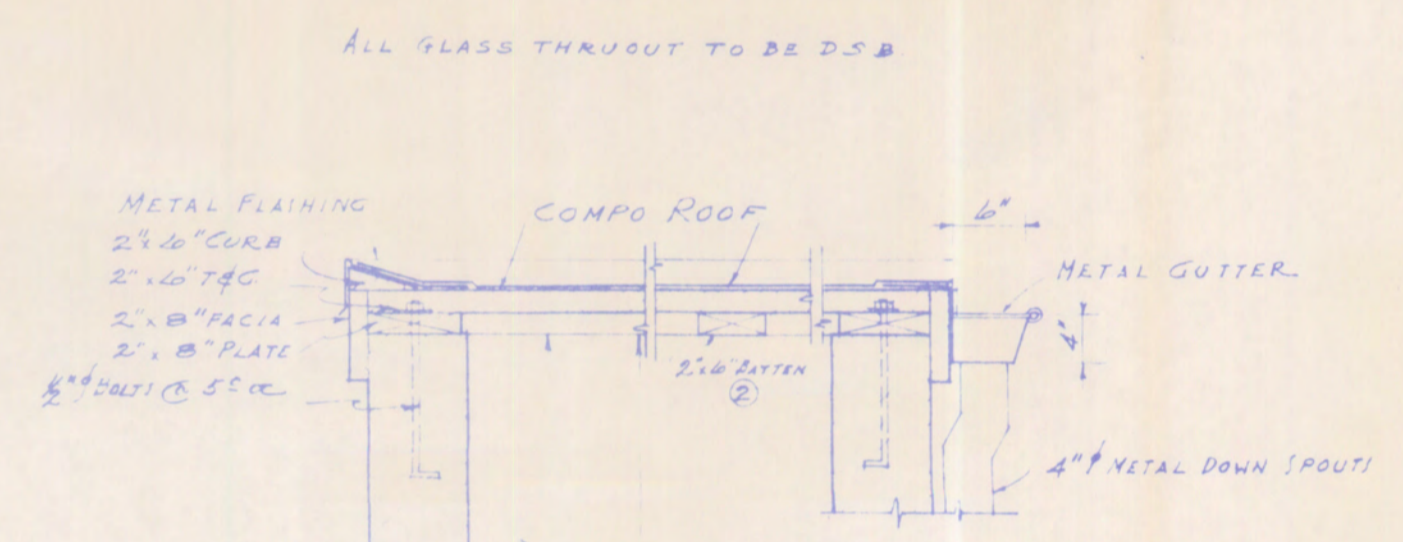


TYPICAL WALL SECTION  
SCALE 1/4" = 1'-0"

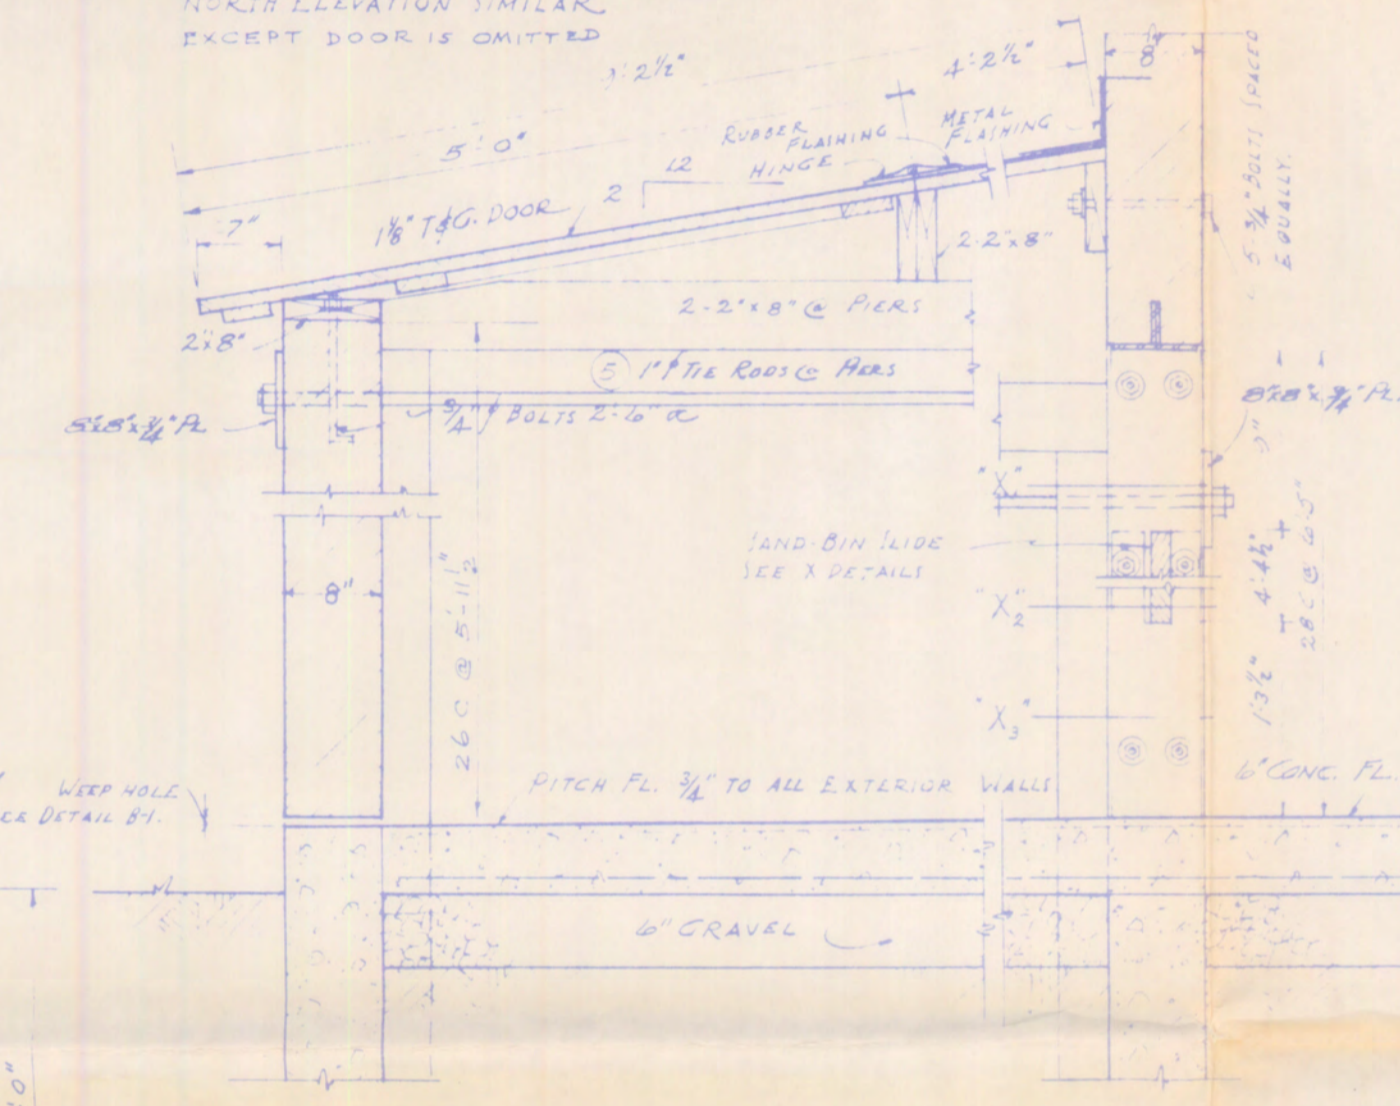

SECTION DETAIL "B-B"  
SCALE 1/2" = 1'-0"

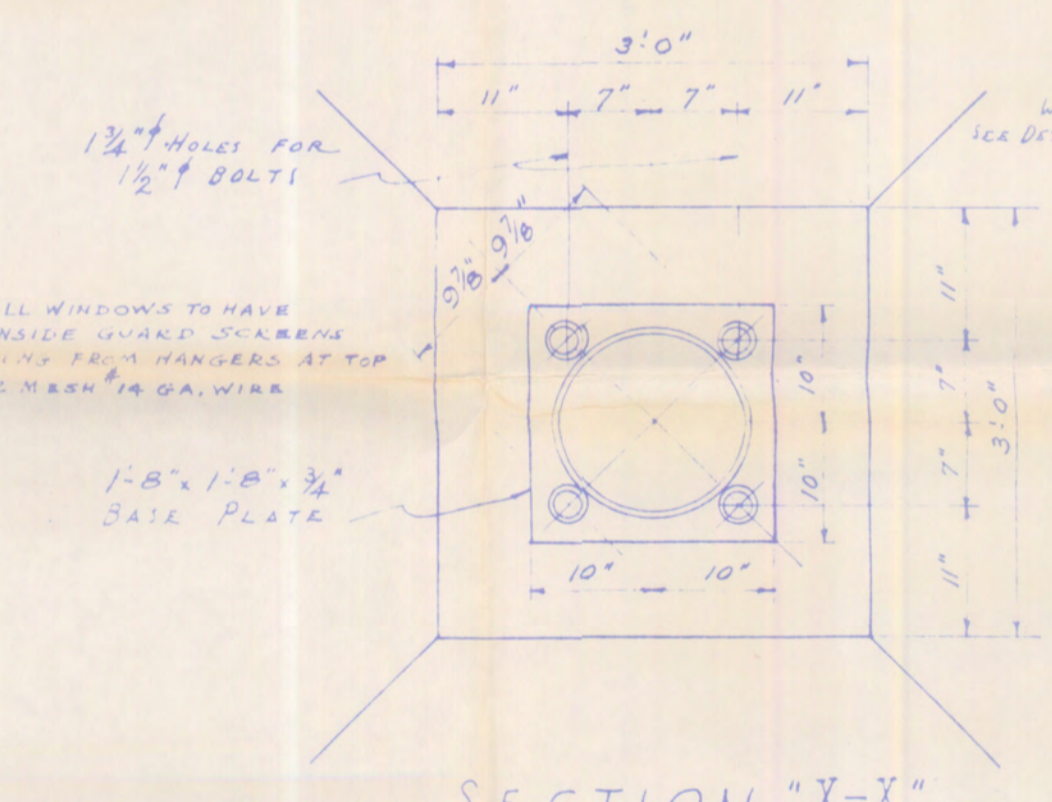


SECTION "X-X"  
SCALE 3/4" = 1'-0"

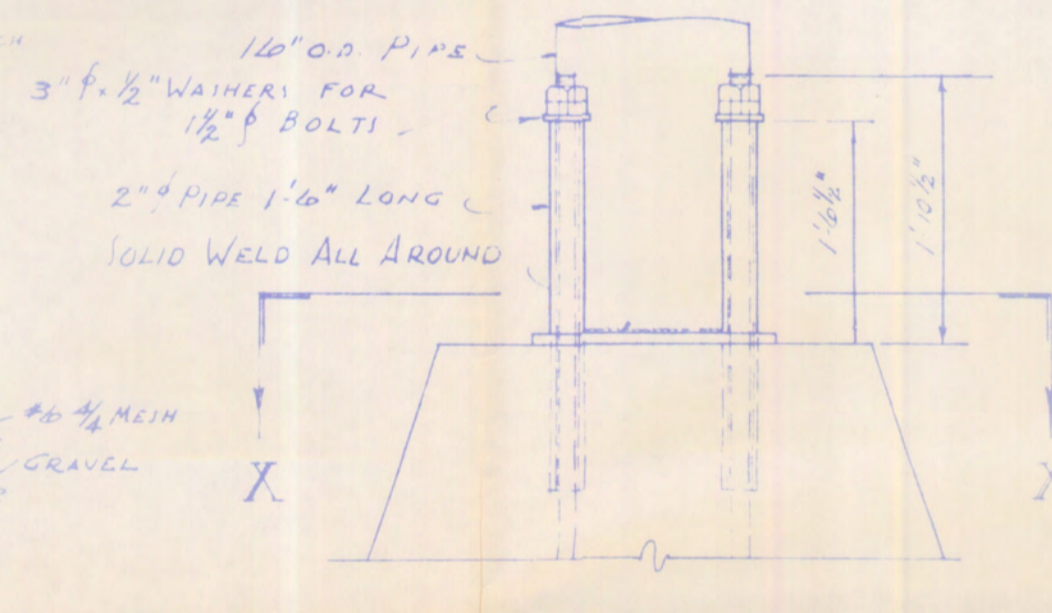


DETAIL OF COLUMN BASE  
SCALE 3/4" = 1'-0"


DETAIL "X1"

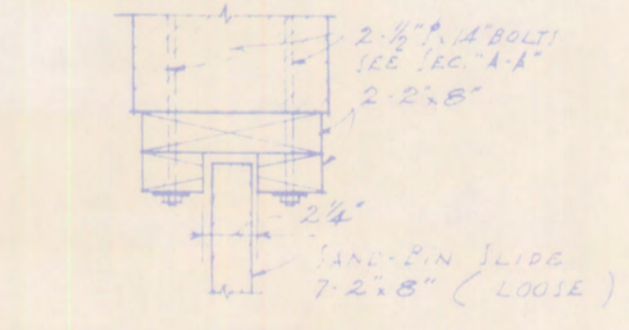

DETAIL "X2"

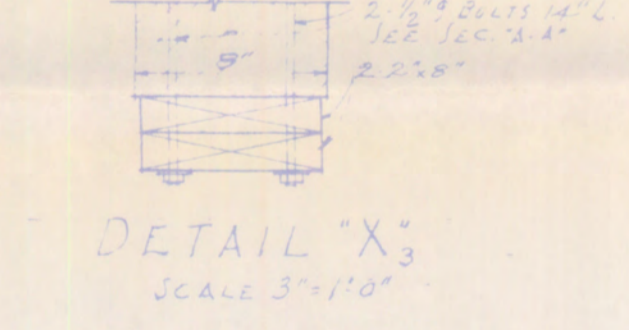

DETAIL "X3"

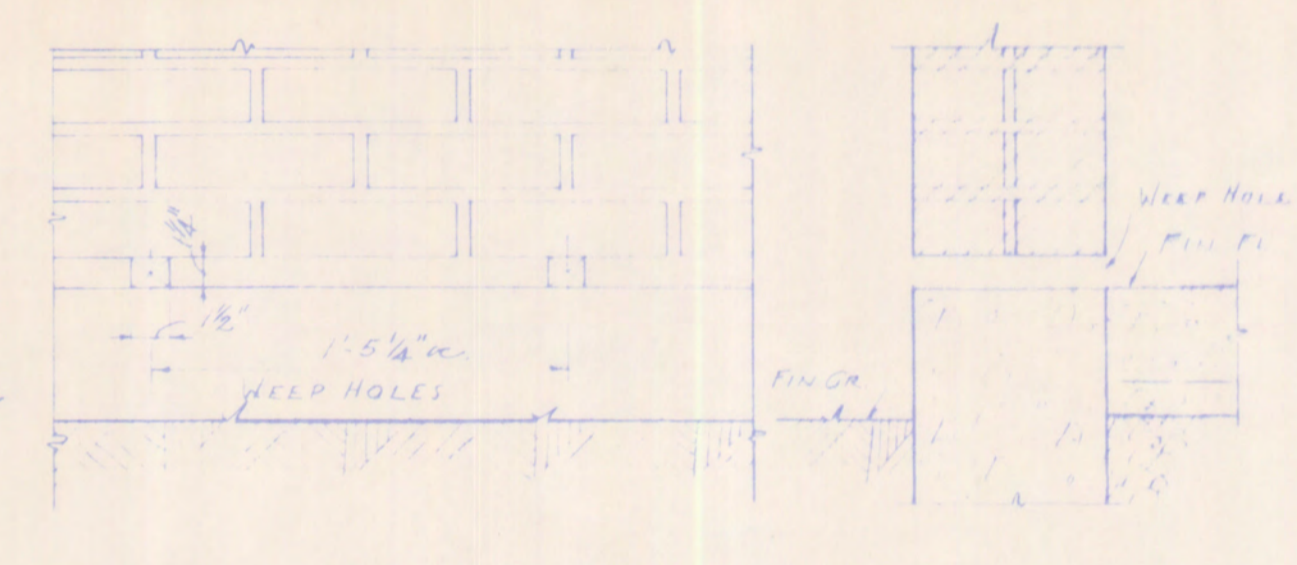

DETAIL "B1"  
SCALE 1/2" = 1'-0"

WEEP HOLES IN 3 EXTERIOR WALLS OF SAND BIN.

REFERENCE DRAWINGS: 200 STANDARD ARCHITECTURAL DETAILS.

DRAWING INDEX			
DRWG NO	TITLE	APPLIES TO	NOTES
1A-59	PLANS, ELEVATIONS, SECTION & DET	47-59	
1M-59	PIPING PLAN & DETAILS	47-59	
1E-59	LIGHTING & POWER LAYOUT	47-59	

THIS DRAWING APPLIES TO BUILDING NUMBER 47-59.

RAVENNA ARMY AMMUNITION PLANT			
OPERATED BY RAVENNA ARSENAL, INC. 47-59			
APPROVED	SIGNATURE	DATE	TITLE
			TRANSPORTATION AREA
			OIL PUMPING & SAND DRYING BLDG.
			PLAN, ELEVATIONS, SECTION & DETAIL
			48'-0" x 8'-0" TYPE 39
			REF. DWG NO.
			DRWN. CLR. CHKD. ENGR.
			DATE 5/14/69
			SCALE 1056.201