

DRAWING REVISED PER FIELD SURVEY
 DATE MARCH 11, 1957
 CONTRACT NO. DA-11-173-DRD-65
 TRYGVE HOFF & ASSOCIATES
 REV. BY A.S. CHK'D BY F.N.M.


REVISIONS NO. 1, 2 AND 3 APPROVED BY -
 L. H. EATON · PLANT ENGINEER
 C. H. WILLISTON · ASST. GENERAL MANAGER
 C. W. MELDRUM · LT. COL. ORDN. DEPT. COMMANDING

~ REFERENCE DRAWINGS ~
 General Plan - Dwg. 6988.326-A
 Administration & Utilities Area - Water Lines - Dwg. 6988.684
 Administration & Utilities Area - Sanitary Sewer System - Dwg. 6988.683-A

BUILDING NO U-15 NO LONGER EXISTS.

DRAWING REVISED PER FIELD SURVEY
 DATE 29 APRIL 1970
 RAVENNA ARMY AMMUNITION PLANT
 REV. BY T.G.O. CHK'D BY J.W.O.

- ① LIST OF REFERENCE DRAWINGS USED IN ORIGINAL CONSTRUCTION:
- 700-1254 - FLOOR PLANS & ELEVATIONS - Constr. Div., Office of Q. M. G. - Rev. J.L.G.
 - 700-1300 - WALL SECTIONS & DETAILS - Constr. Div., Office of Q. M. G. rev. 1-20-42
 - 700-1301 - KITCHEN & STAIR DETAILS - Constr. Div., Office of Q. M. G. rev. 5-19-41
 - 700-1302 - MISCELLANEOUS DETAILS - Constr. Div., Office of Q. M. G. rev. 5-19-41
 - 800-190 - SMOKE PIPE & FLUE DETAILS - Constr. Div., Office of Q. M. G. rev. 5-23-42
 - 800-194 - STANDARD PLUMBING DETAILS - Constr. Div., Office of Q. M. G. rev. 6-6-42
 - 800-196 - STANDARD HEATING DETAILS - Constr. Div., Office of Q. M. G. rev. 7-24-41
 - 800-199 - STANDARD ELECTRICAL DETAILS - Constr. Div., Office of Q. M. G. rev. 8-21-41

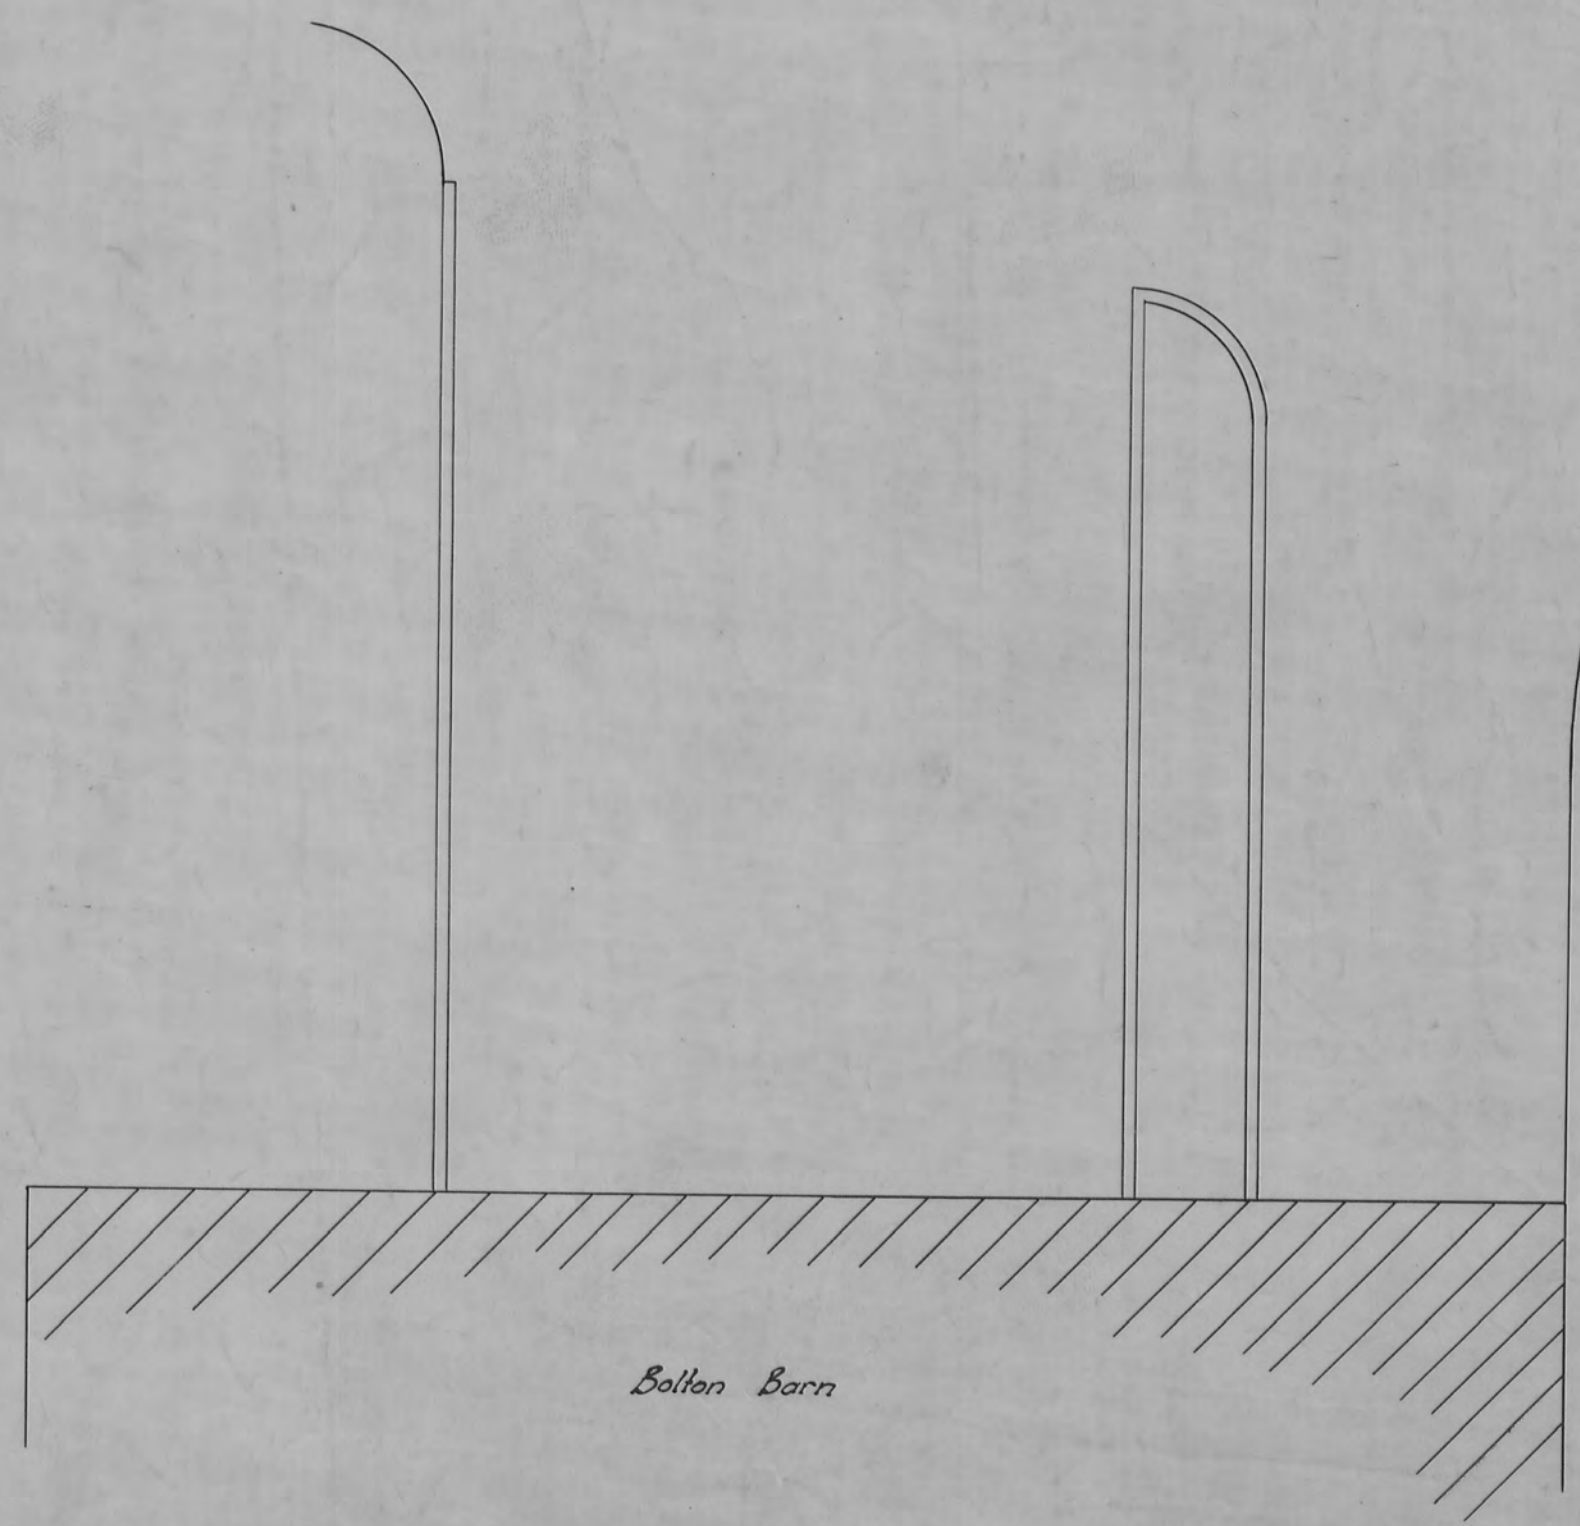

② BUILDING NO. U-15

③ BLDG. USED AS CIVILIAN DORMITORY as of Nov. 22, 1944.

THE JENNINGS - LAWRENCE CO.
 ARCHITECT-ENGINEER
 COLUMBUS, O. RAVENNA, O.

SCALE 1" = 20'

CONSTRUCTION DIVISION
 OFFICE OF THE CHIEF OF ENGINEERS

**PORTAGE ORDNANCE DEPOT
 OFFICERS QUARTERS & MESS** ②
 SITE PLAN

REVISIONS	DWG. LIST	DATE
①	BLDG. AN	7/27/44
②	PREP. USR	7/27/44
③	T. HOFF & ASSOCIATES	3/11/57
④		

DRAWN BY A.F.L. A.T.	CHECKED BY	APPROVED BY DIRECTION	DATE July 27, 1942
TRACED BY T.G.G.		<i>T.G. Smith</i> CAPT. C. OF E. AREA ENGR	PLAN NUMBER 6988-625

APPROVED
Marvin L. Kafer
 MARVIN L. KAFER
 MAJOR - ORDNANCE DEPT.
 COMMANDING OFFICER