




FLOOR PLAN
SCALE 1/4" = 1'-0"

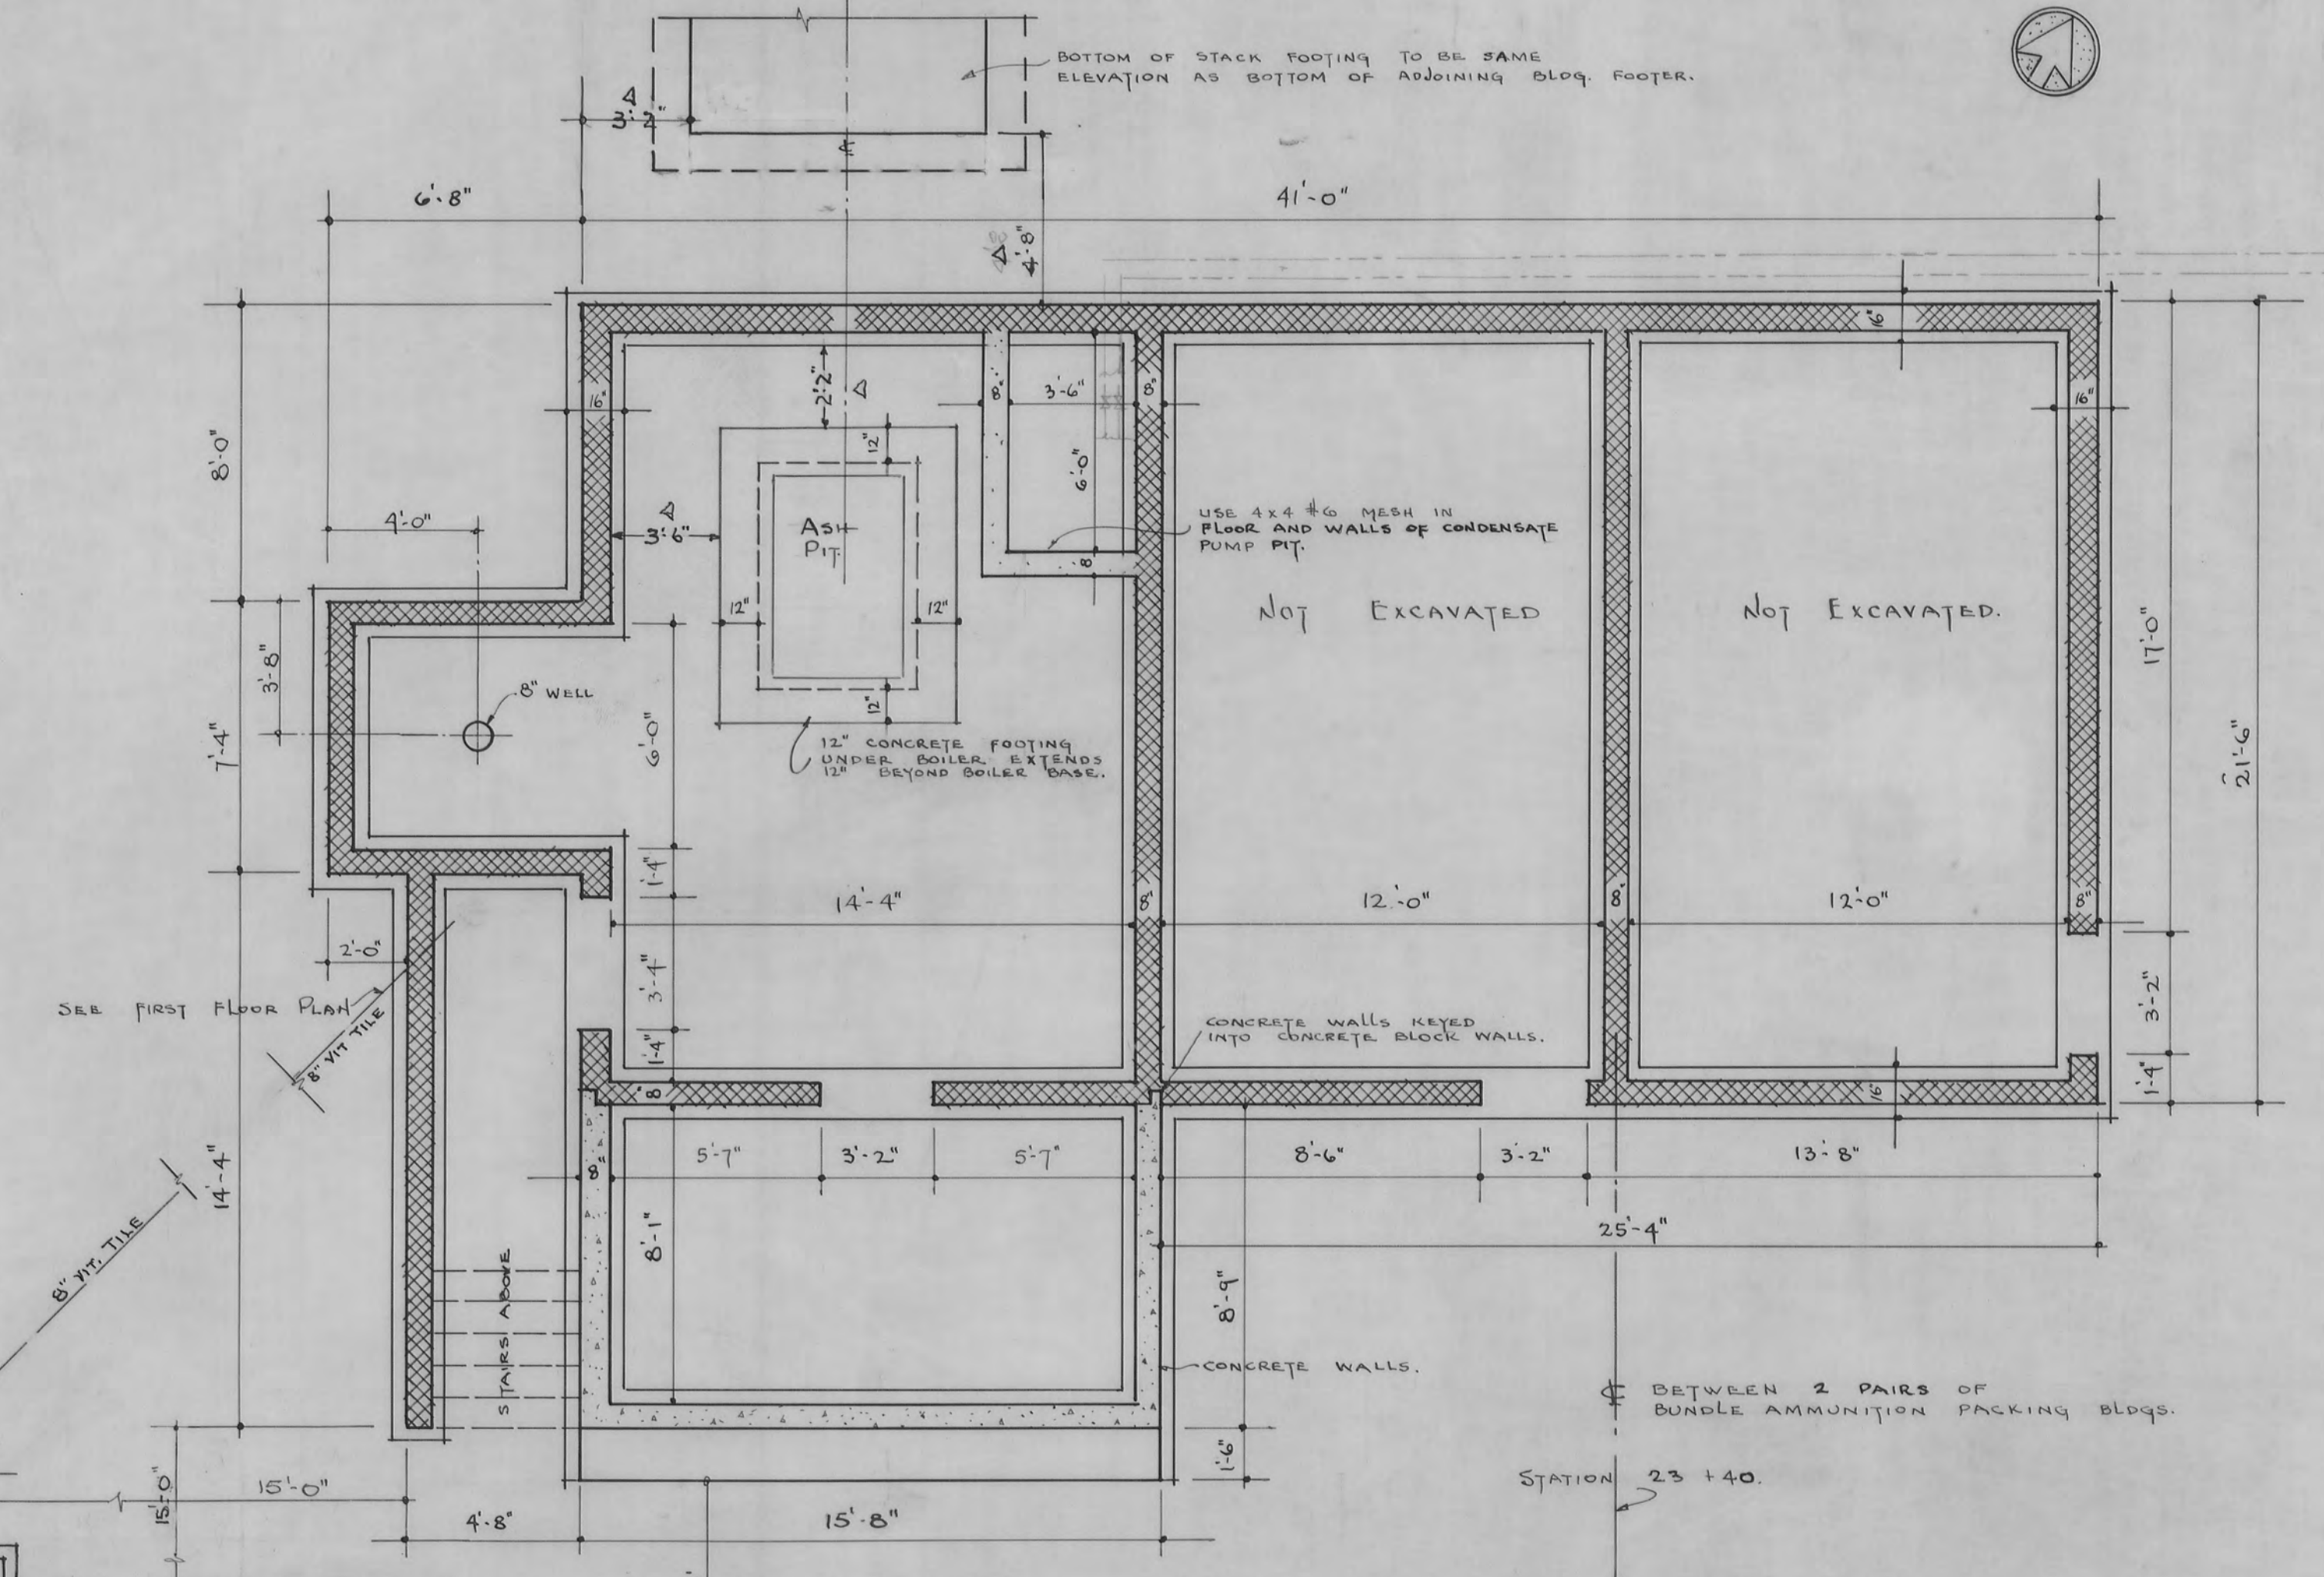

FOUNDATION PLAN
SCALE 1/4" = 1'-0"

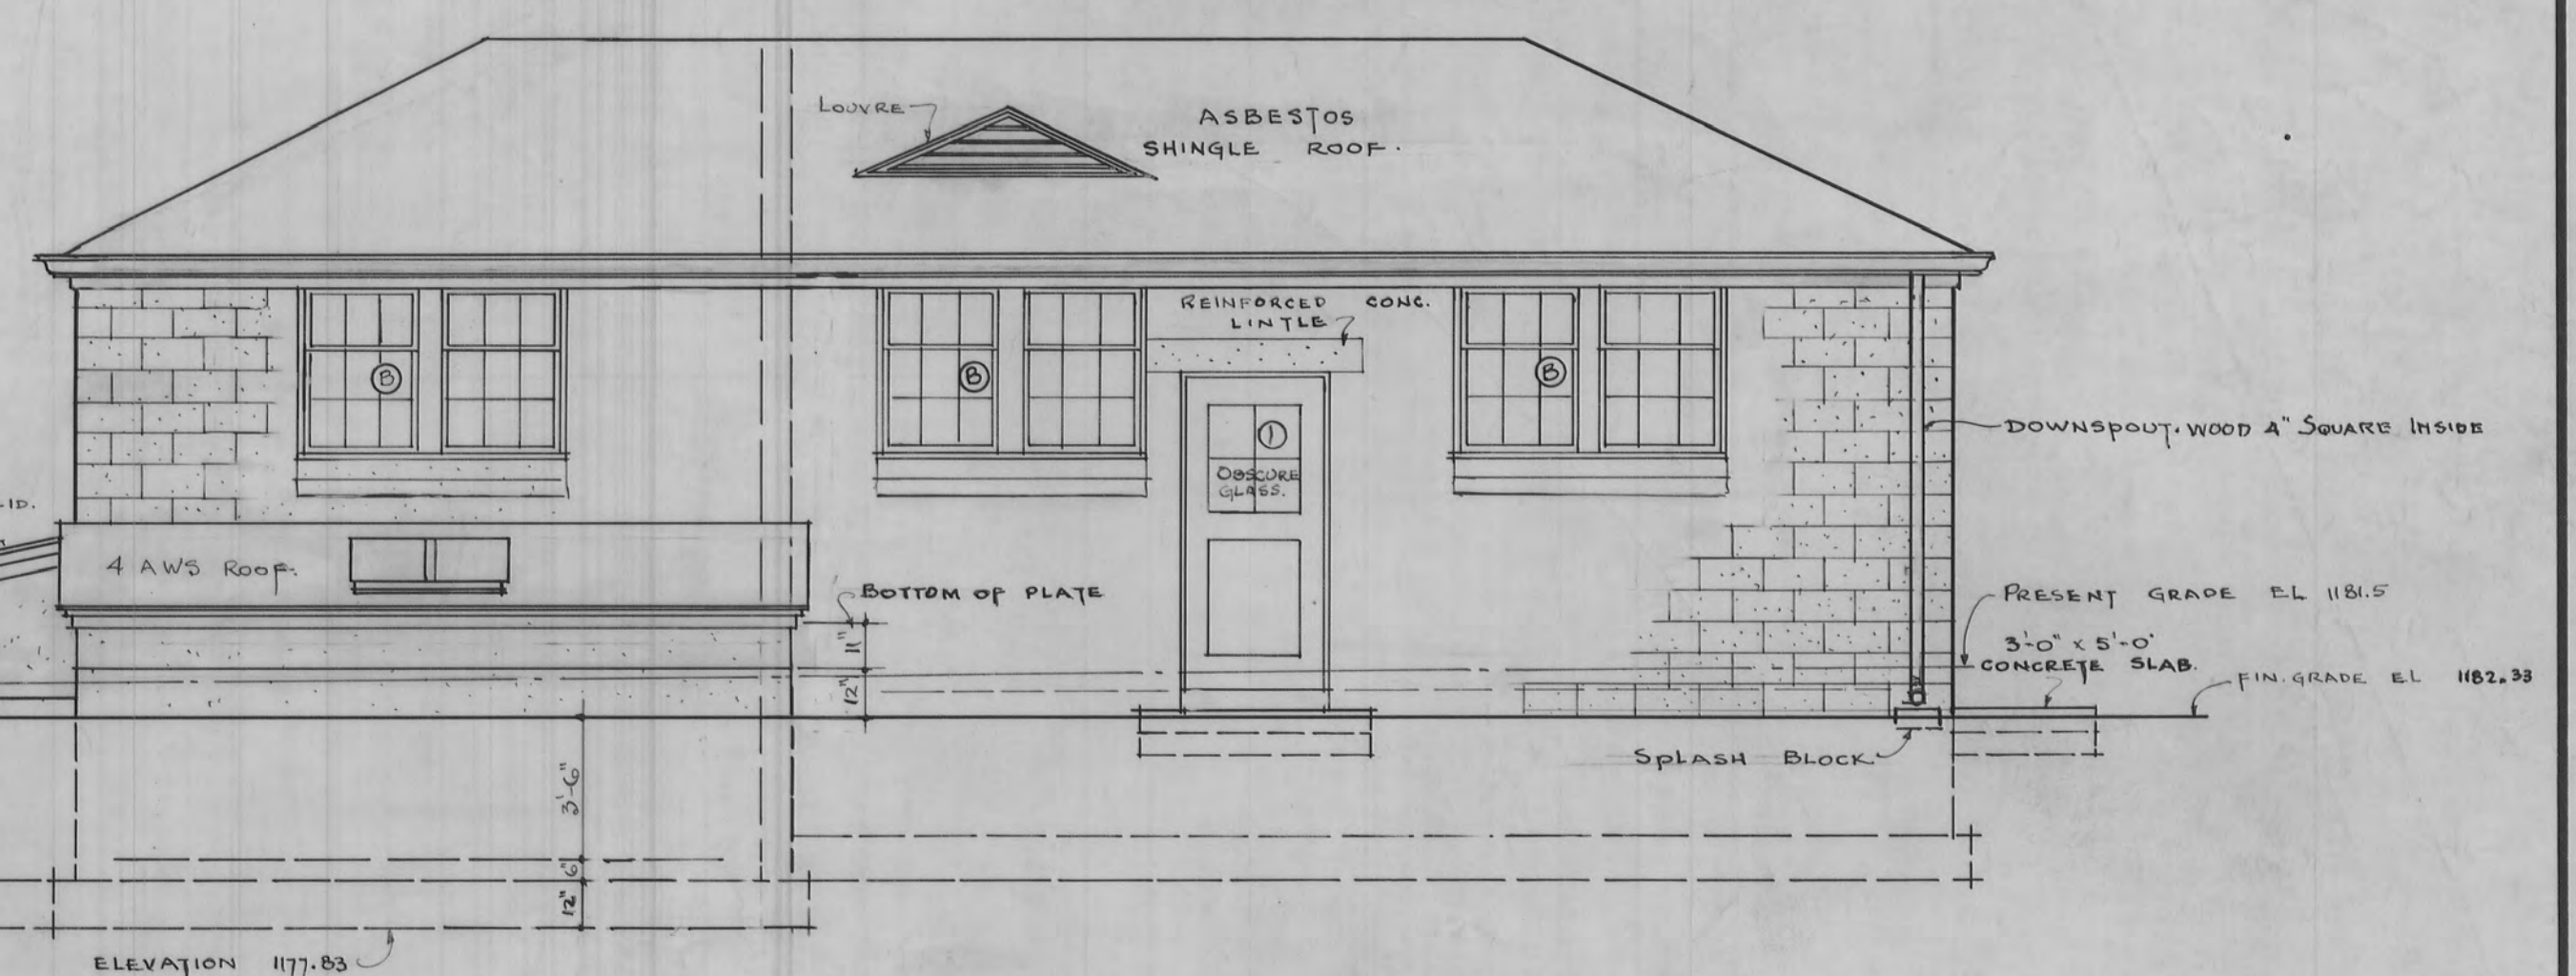

SOUTH ELEVATION
SCALE 1/4" = 1'-0"

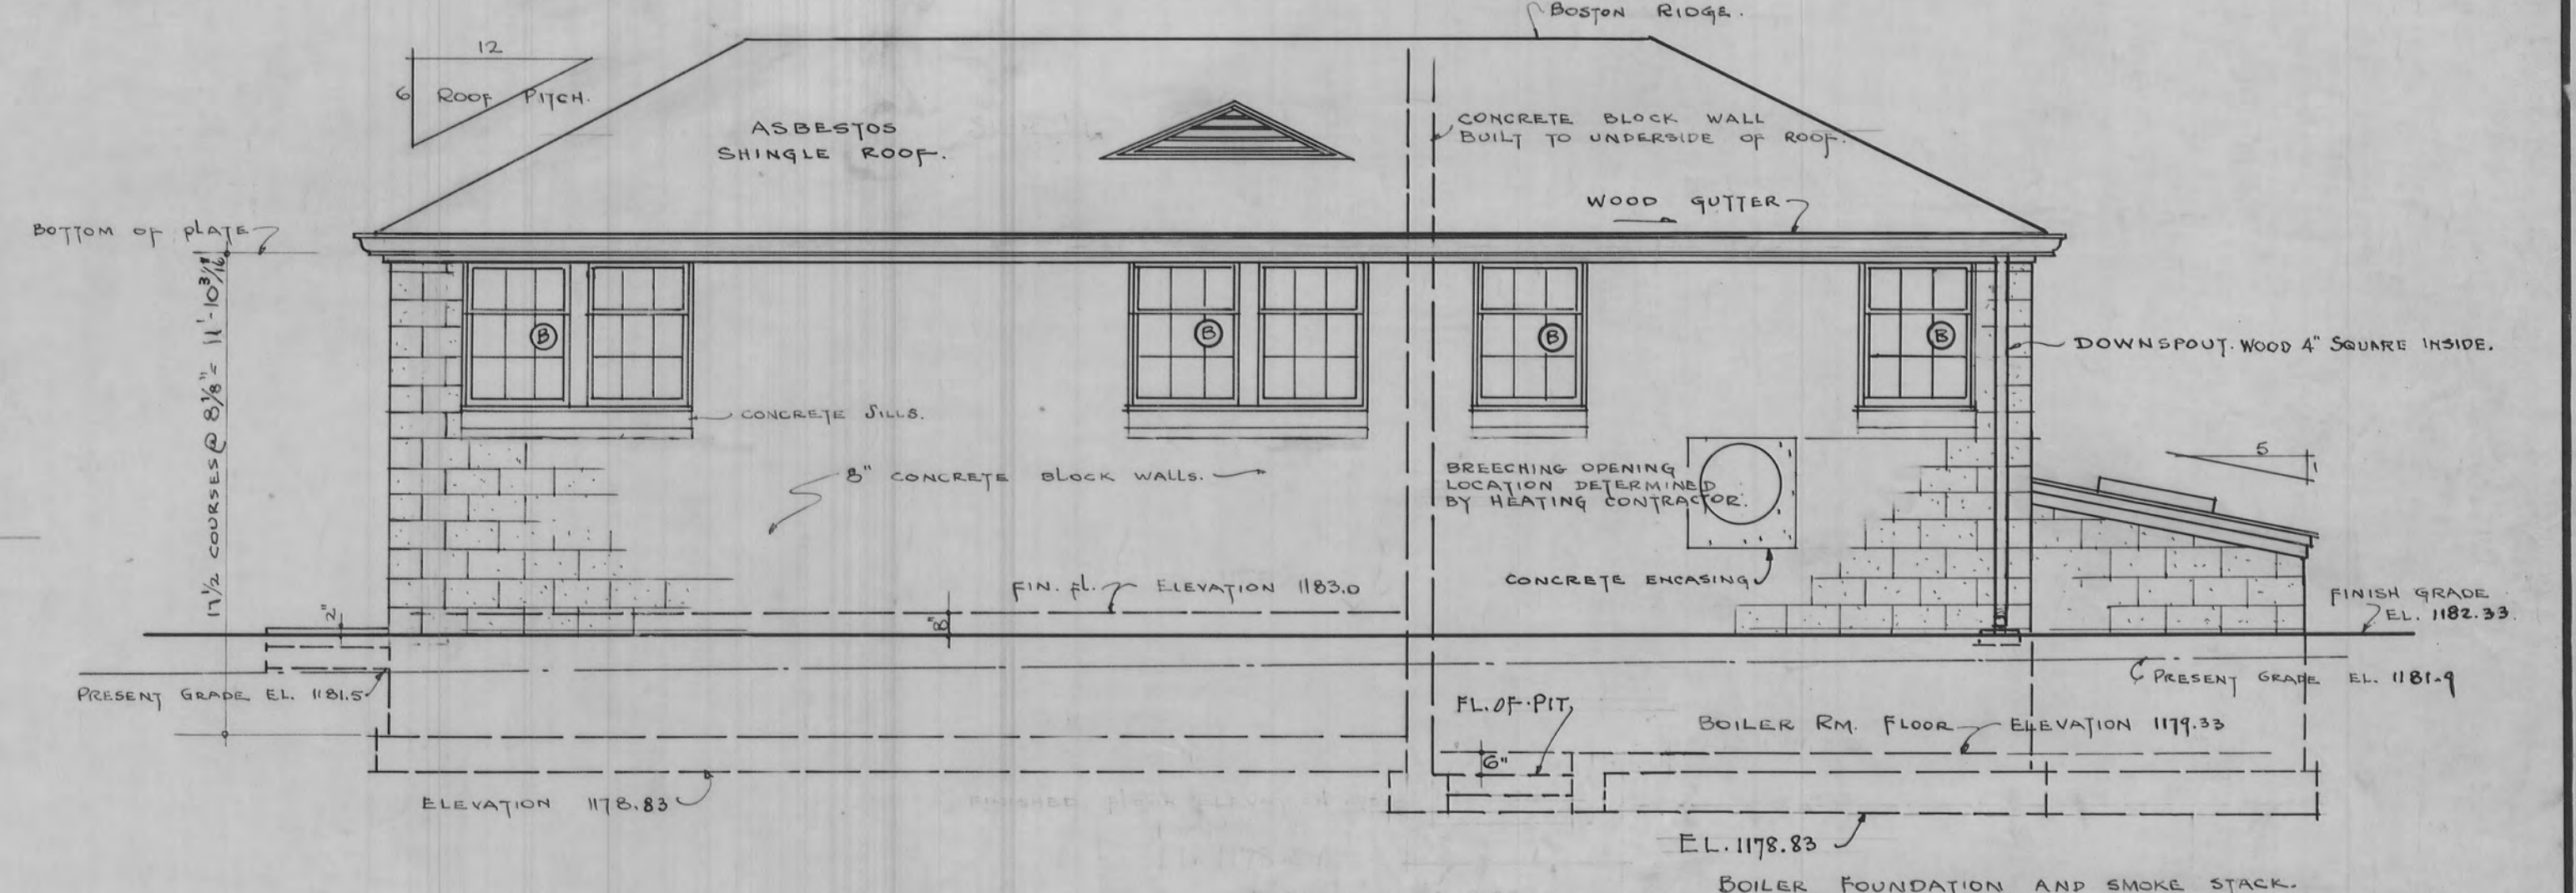

NORTH ELEVATION
SCALE 1/4" = 1'-0"

WINDOW SCHEDULE		
A	SINGLE DOUBLE HUNG—UPPER DIV. 3LTS—LOWER DIV. 6LTS	9 x 12
B	TWIN DOUBLE HUNG—UPPER DIV. 3LTS—LOWER DIV. 6LTS	9 x 12

△ CABINET & DRINKING FOUNTAIN IN TOILET ROOM MOVED—URINAL TROUGH CHANGED TO THREE INDIVIDUAL URINALS.

DOOR SCHEDULE		
1	3'-0" x 7'-0" x 1 3/4" TOP GLAZED WITH OBSCURE GLASS.	
2	4'-0" x 7'-4" x 2" METAL CLAD—SELF CLOSING	

APPROVED...
Maurin Kaper
MARVIN L. KAPER
MAJOR—ORDNANCE DEPT.
COMMANDING OFFICER.

THE JENNINGS—LAWRENCE CO.
ARCHITECT-ENGINEER
COLUMBUS, O. RAVENNA, O.

CONSTRUCTION DIVISION
OFFICE OF THE CHIEF OF ENGINEERS.

BUILDING NO. J-10

PORTAGE ORDNANCE DEPOT
BOILER HOUSE & TOILETS FOR
BUNDLE AMMUNITION PACKING BLDGS.
FOUNDATION & FLOOR PLANS—ELEVATIONS.

DRAWN BY ECF	CHECKED BY ECF	APPROVED BY DIRECTION <i>J.E. Smith</i> CAPT. CO. E. AREA ENGR.	DATE OCT. 14, 1942
TRACED BY ECF			PLAN NUMBER 6988-655

REVISION NO. 4 APPROVED BY:
DRAWING REVISED PER FIELD SURVEY
DATE NOVEMBER 15TH 1956
CONTRACT NO. DA-11-173-ORD-65
TRYGVE HOFF & ASSOCIATES
REV. BY K.C. CHK'D BY E.N.M.
See Gen. Plan 6988-326 A
L. H. EATON · PLANT ENGINEER
C. H. WILLISTON · ASST. GEN'L. MGR.
C. W. MELDRUM · LT. COL. ORD. DEPT. COMMANDING